



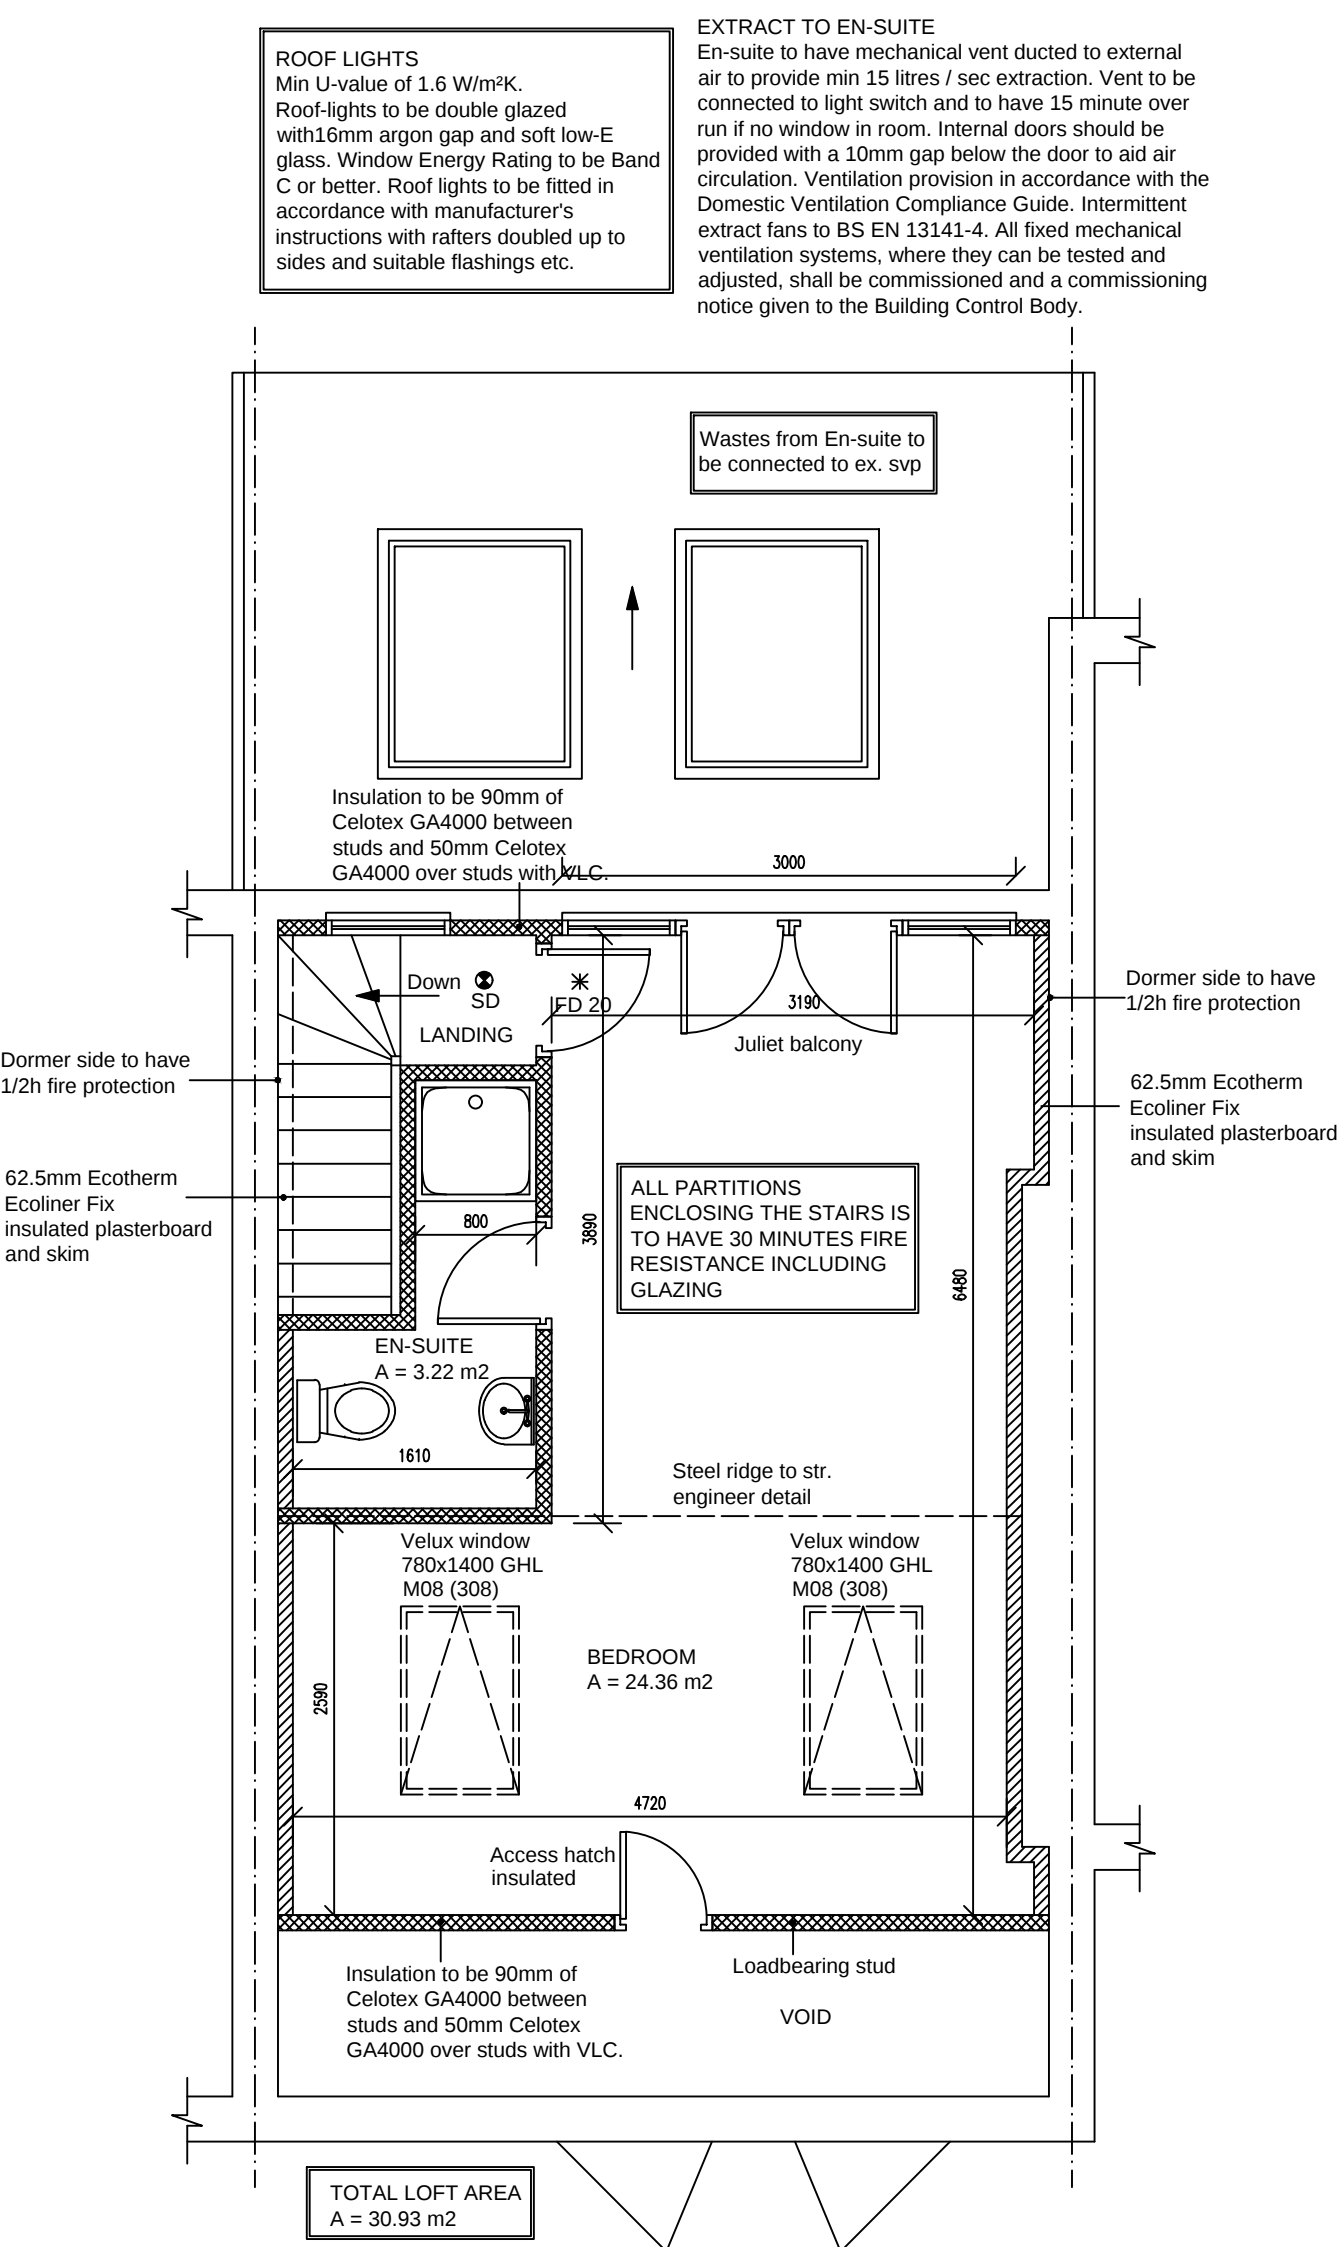


PROPOSED ATTIC FLOOR PLAN
(scale 1:50)

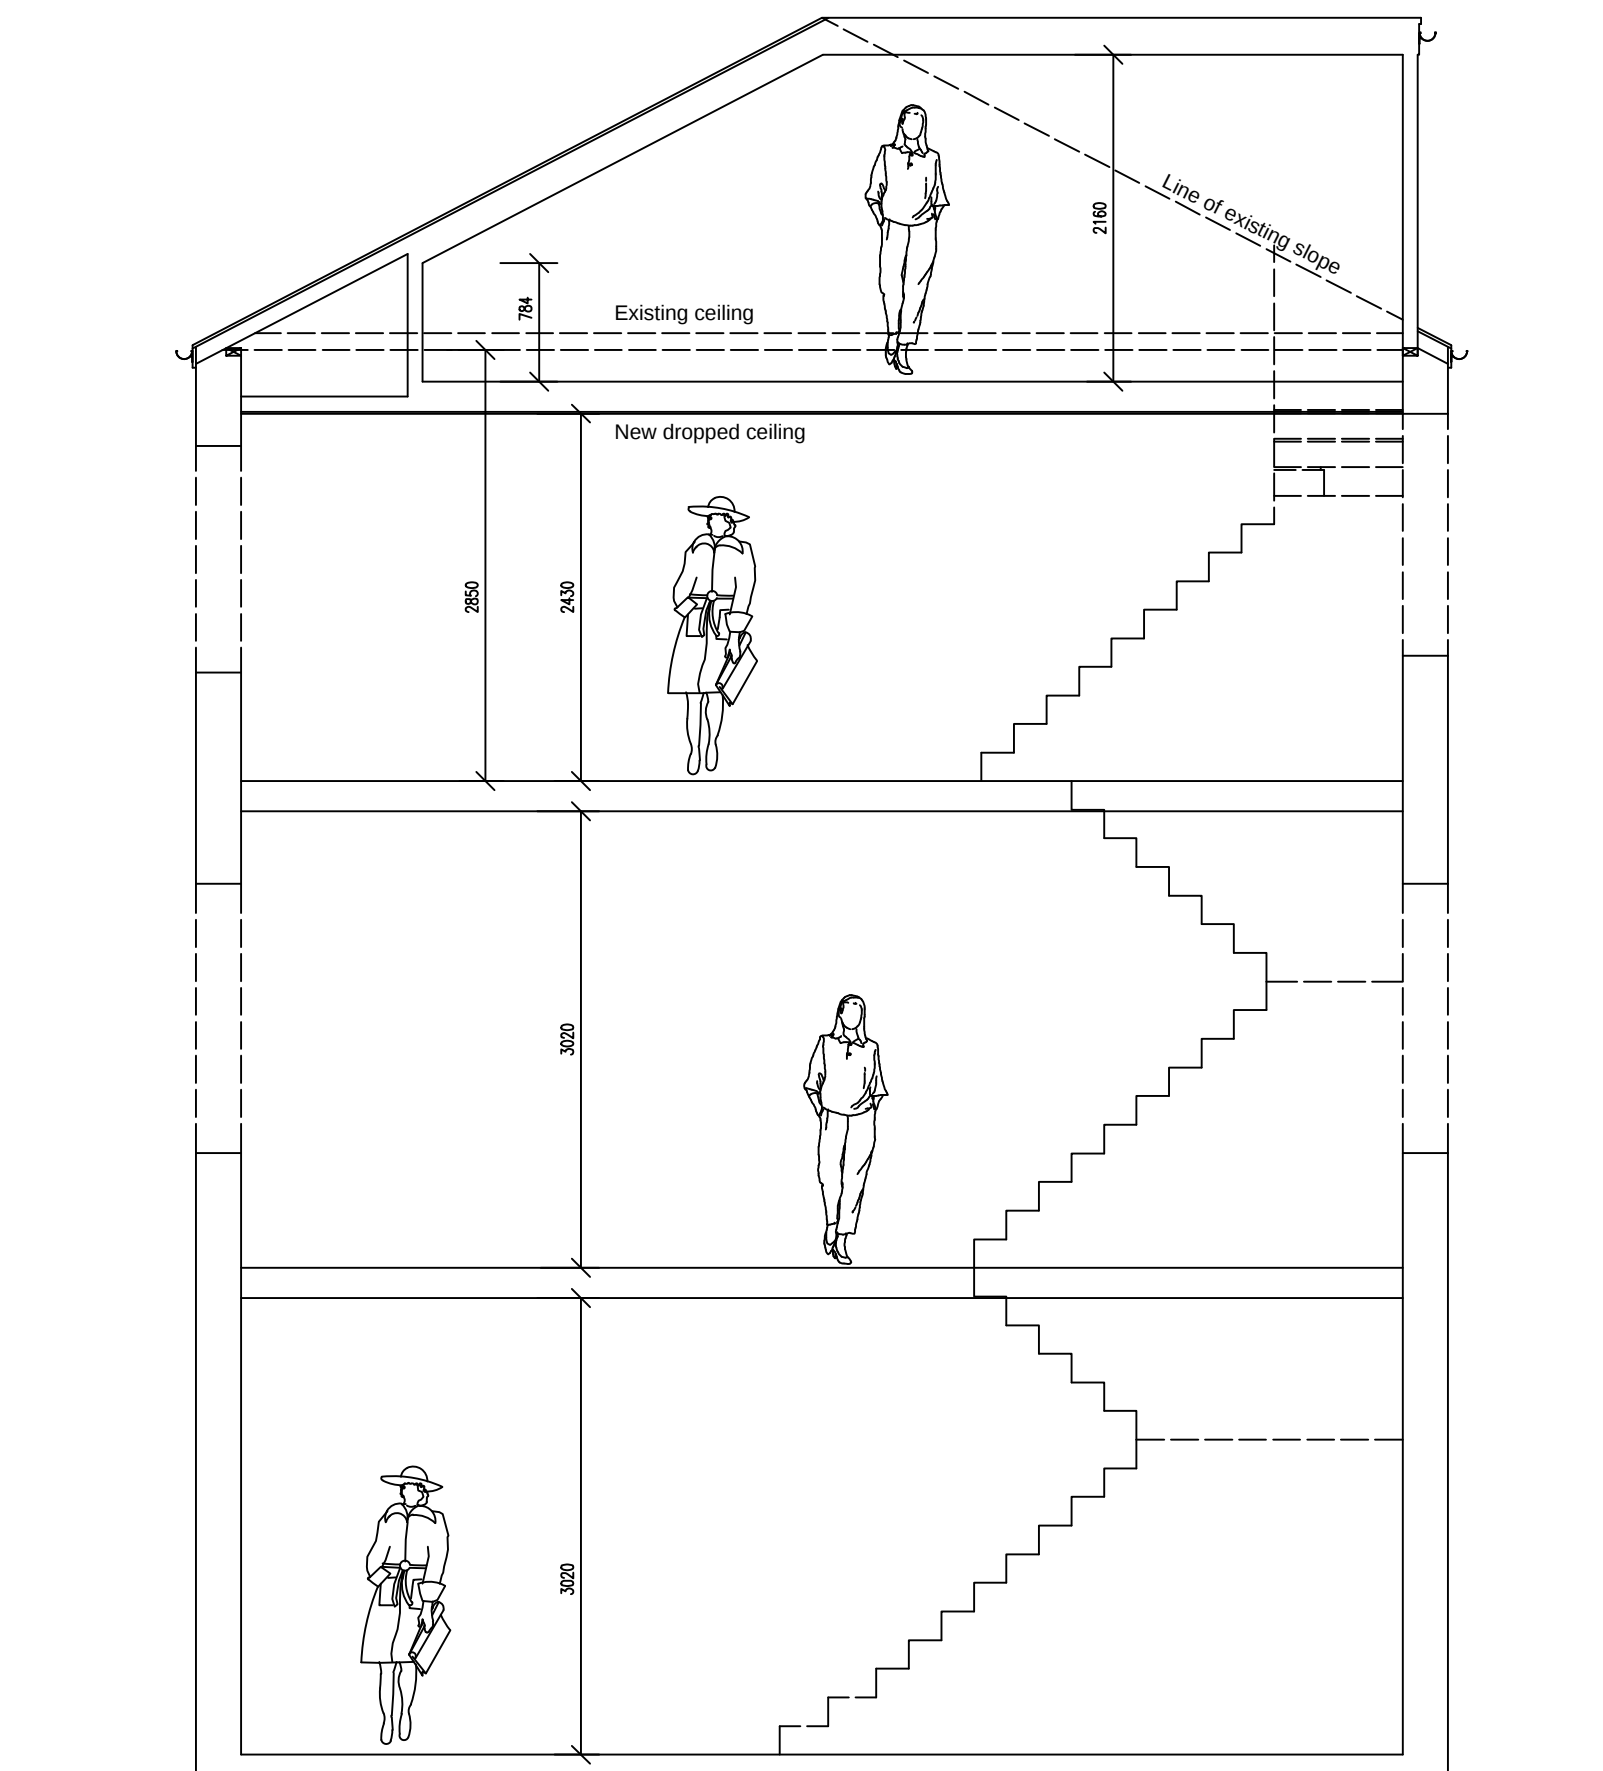

TYPICAL SECTION
(scale 1:50)

THIS DRAWING IS © S.E.R. DO NOT SCALE FROM THIS DRAWING. ANY ERROR TO BE REPORTED BEFORE WORKS ARE CARRIED OUT. THESE DRAWINGS ARE NOT FOR CONSTRUCTION USE AND ALL DIMENSIONS ARE TO BE VERIFIED UNLESS STATED.

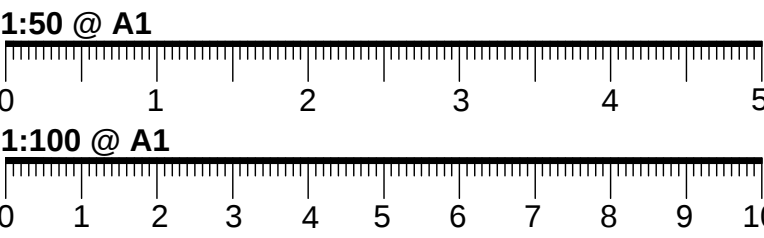

NOTES:

- THESE DRAWINGS ARE FOR BUILDING ILLUSTRATION PURPOSES ONLY
- (REFER TO BUILDING SPEC FOR FURTHER INFORMATION)
- DIMENSIONS ARE TO BE CHECKED ON SITE PRIOR TO ANY CONSTRUCTION
- REFER TO STRUCTURAL ENGINEER REPORT FOR STEEL WORKS, THESE DRAWINGS ARE FOR ILLUSTRATION PURPOSES ONLY
- ELECTRICAL LAYOUT TO BE CONFIRMED BY CLIENT ON SITE WITH BUILDER
- PLUMBING TO CONNECT TO EXISTING

KEY:

- SITE BOUNDARY
- - - DEMOLITION
- DRAINAGE
- LIGHT LAYOUT TBC

KEY:

- (DS) MAINS CONNECTED SMOKE DETECTOR
- (HD) MAINS CONNECTED HEAT DETECTOR
- (XX-X) (REFER TO BUILDING SPEC NOTES)
- FFL+XXX FINISHED FLOOR LEVEL
- FE/RL FIRE ESCAPE ROPE LOCATION
- FR/ER FIRE ESCAPE ROUTE WINDOW
- FD-30 FIRE RATED DOOR UP TO 30min
- FS-30 FIRE RATED STUD WALL UP TO 30min
- FR-30 FIRE RATED GLASS UP TO 30min



REVISION

DATE/DRAWN



PROJECT	11 Perth Road	
	London	
DRAWING TITLE	PLANNING	
	PROPOSED PLANS	
	& SECTION	
DATE	NOV 23	SCALE @ A1
DRAWN	MC	CHECK SS
STATUS		
JOB NUMBER		
DRAWING NUMBER	DR-A-05	REV D