


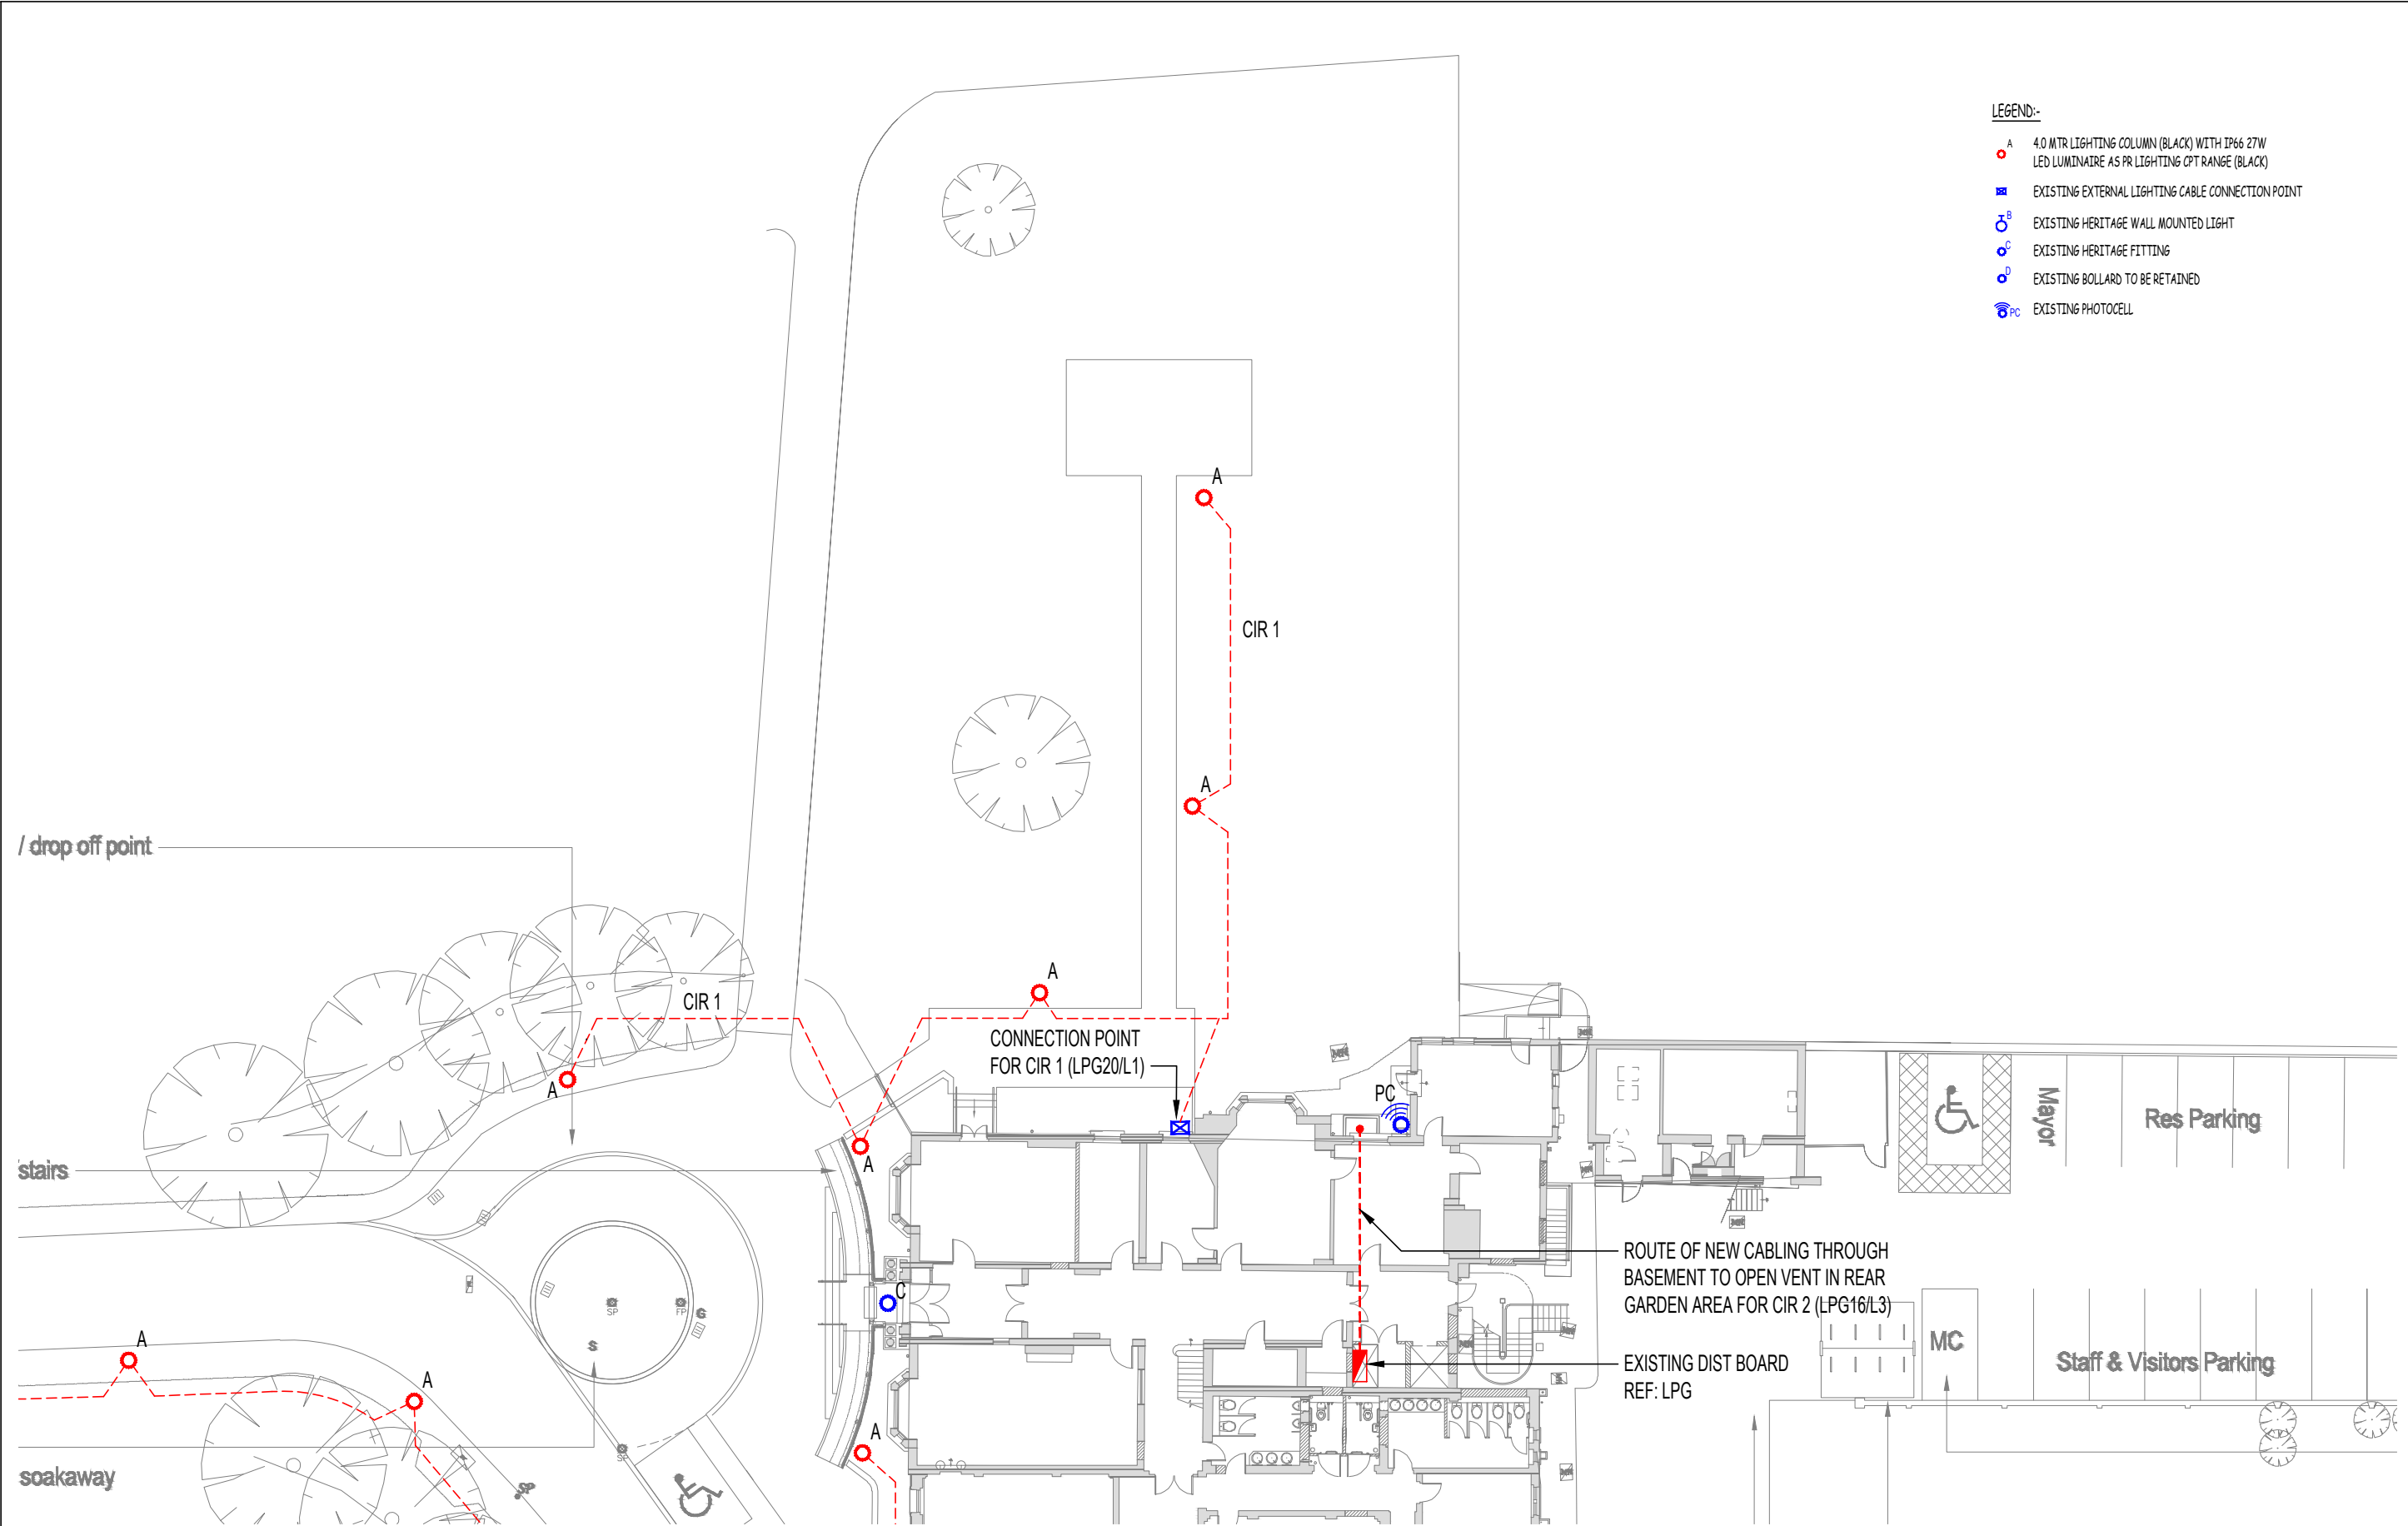

- LEGEND:-
- A 4.0 MTR LIGHTING COLUMN (BLACK) WITH IP66 27W LED LUMINAIRE AS PR LIGHTING CPT RANGE (BLACK)
 - EXISTING EXTERNAL LIGHTING CABLE CONNECTION POINT
 - B EXISTING HERITAGE WALL MOUNTED LIGHT
 - C EXISTING HERITAGE FITTING
 - D EXISTING BOLLARD TO BE RETAINED
 - PC EXISTING PHOTOCELL

04.06.2024	TENDER ISSUE	T1	MDB	AM	
date	description	rev	by	chkd	



SURE CONSULTING
TRIDENT HOUSE
KINGSTON ROAD, LEATHERHEAD
SURREY KT22 7LT
Tel. 01372 365040
e-mail: suregroup@btinternet.com
CONSULTING ENGINEERS

project

George Meehan House

title

External Lighting Layout
Rear

date31.05.2024

scale1:250 @ A3

drawing no.4909-E2

revT1