


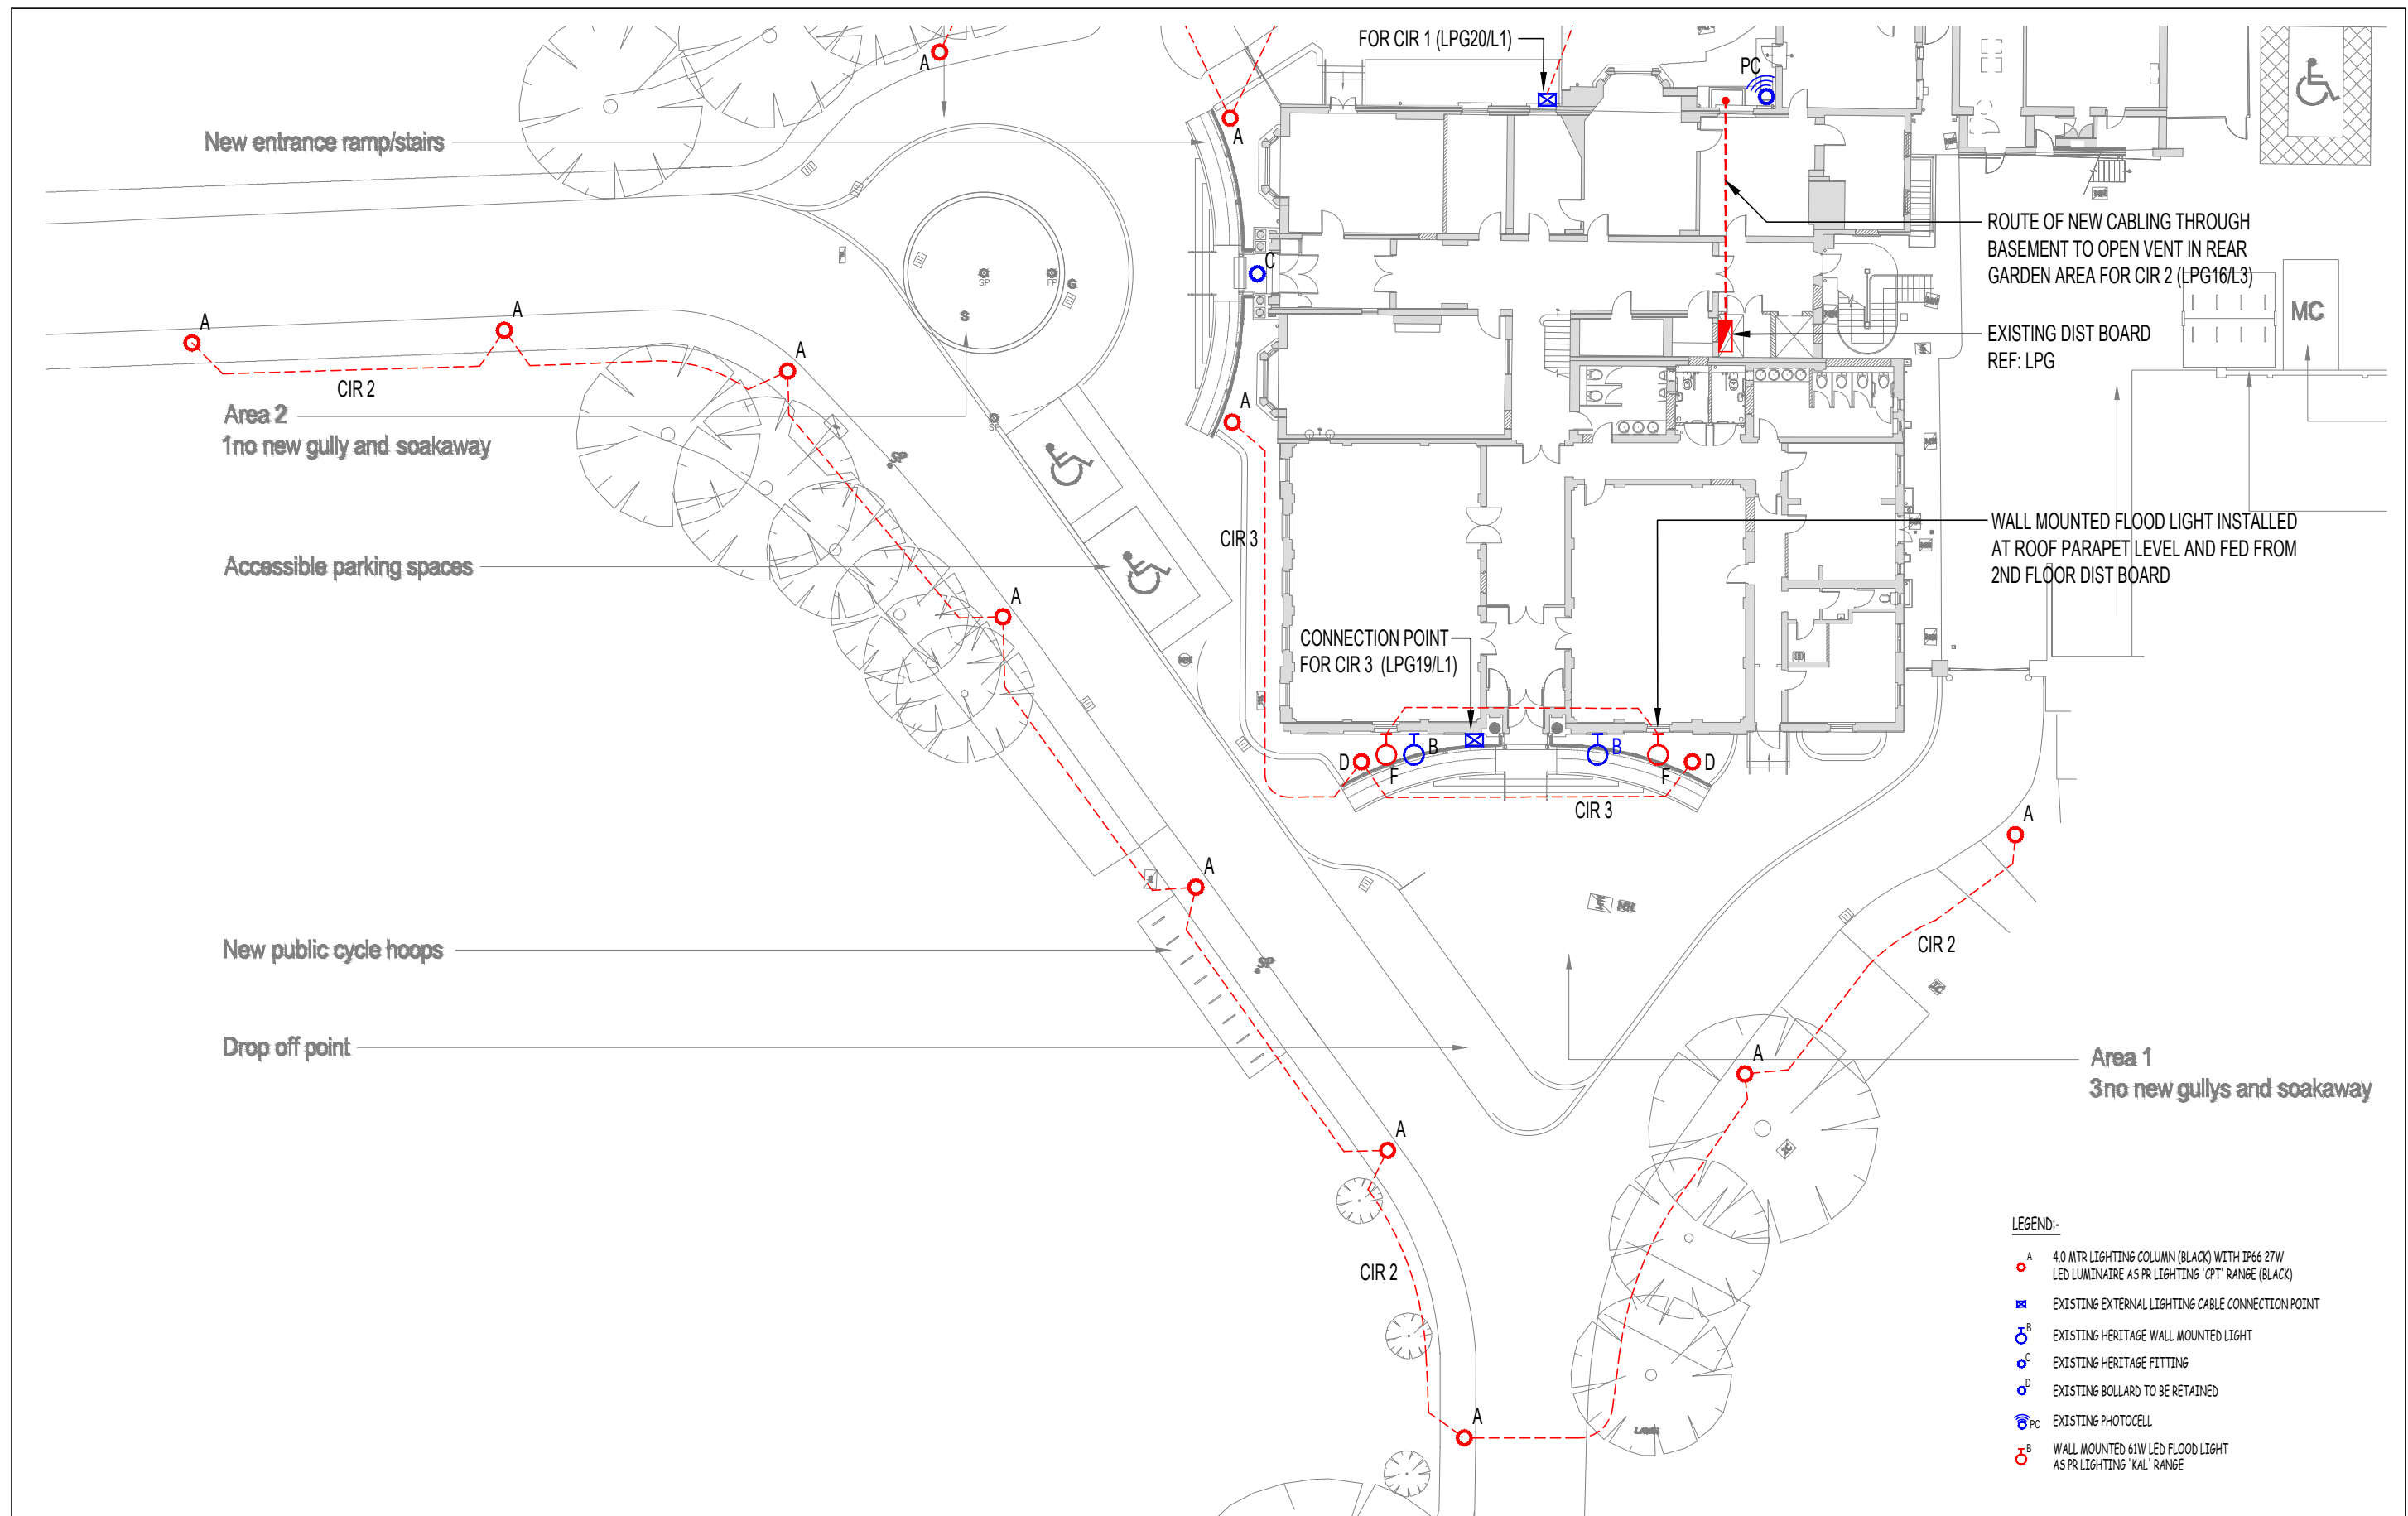

- LEGEND:-
- A 4.0 MTR LIGHTING COLUMN (BLACK) WITH IP66 27W LED LUMINAIRE AS PR LIGHTING 'CPT' RANGE (BLACK)
 - EXISTING EXTERNAL LIGHTING CABLE CONNECTION POINT
 - B EXISTING HERITAGE WALL MOUNTED LIGHT
 - C EXISTING HERITAGE FITTING
 - D EXISTING BOLLARD TO BE RETAINED
 - PC EXISTING PHOTOCELL
 - B WALL MOUNTED 61W LED FLOOD LIGHT AS PR LIGHTING 'KAL' RANGE

20.08.2024	ROOF PARAPET FLOOD LIGHTS ADDED	T2	MDB	AM
04.06.2024	TENDER ISSUE	T1	MDB	AM
date	description	rev	by	chkd



SURE CONSULTING
TRIDENT HOUSE
KINGSTON ROAD, LEATHERHEAD
SURREY KT22 7LT
Tel. 01372 365040
e-mail: suregroup@btinternet.com
CONSULTING ENGINEERS

project
George Meehan House

title
External Lighting Layout
Front

date 31.05.2024
scale 1:250 @ A3

drawing no. 4909-E1

rev T2