


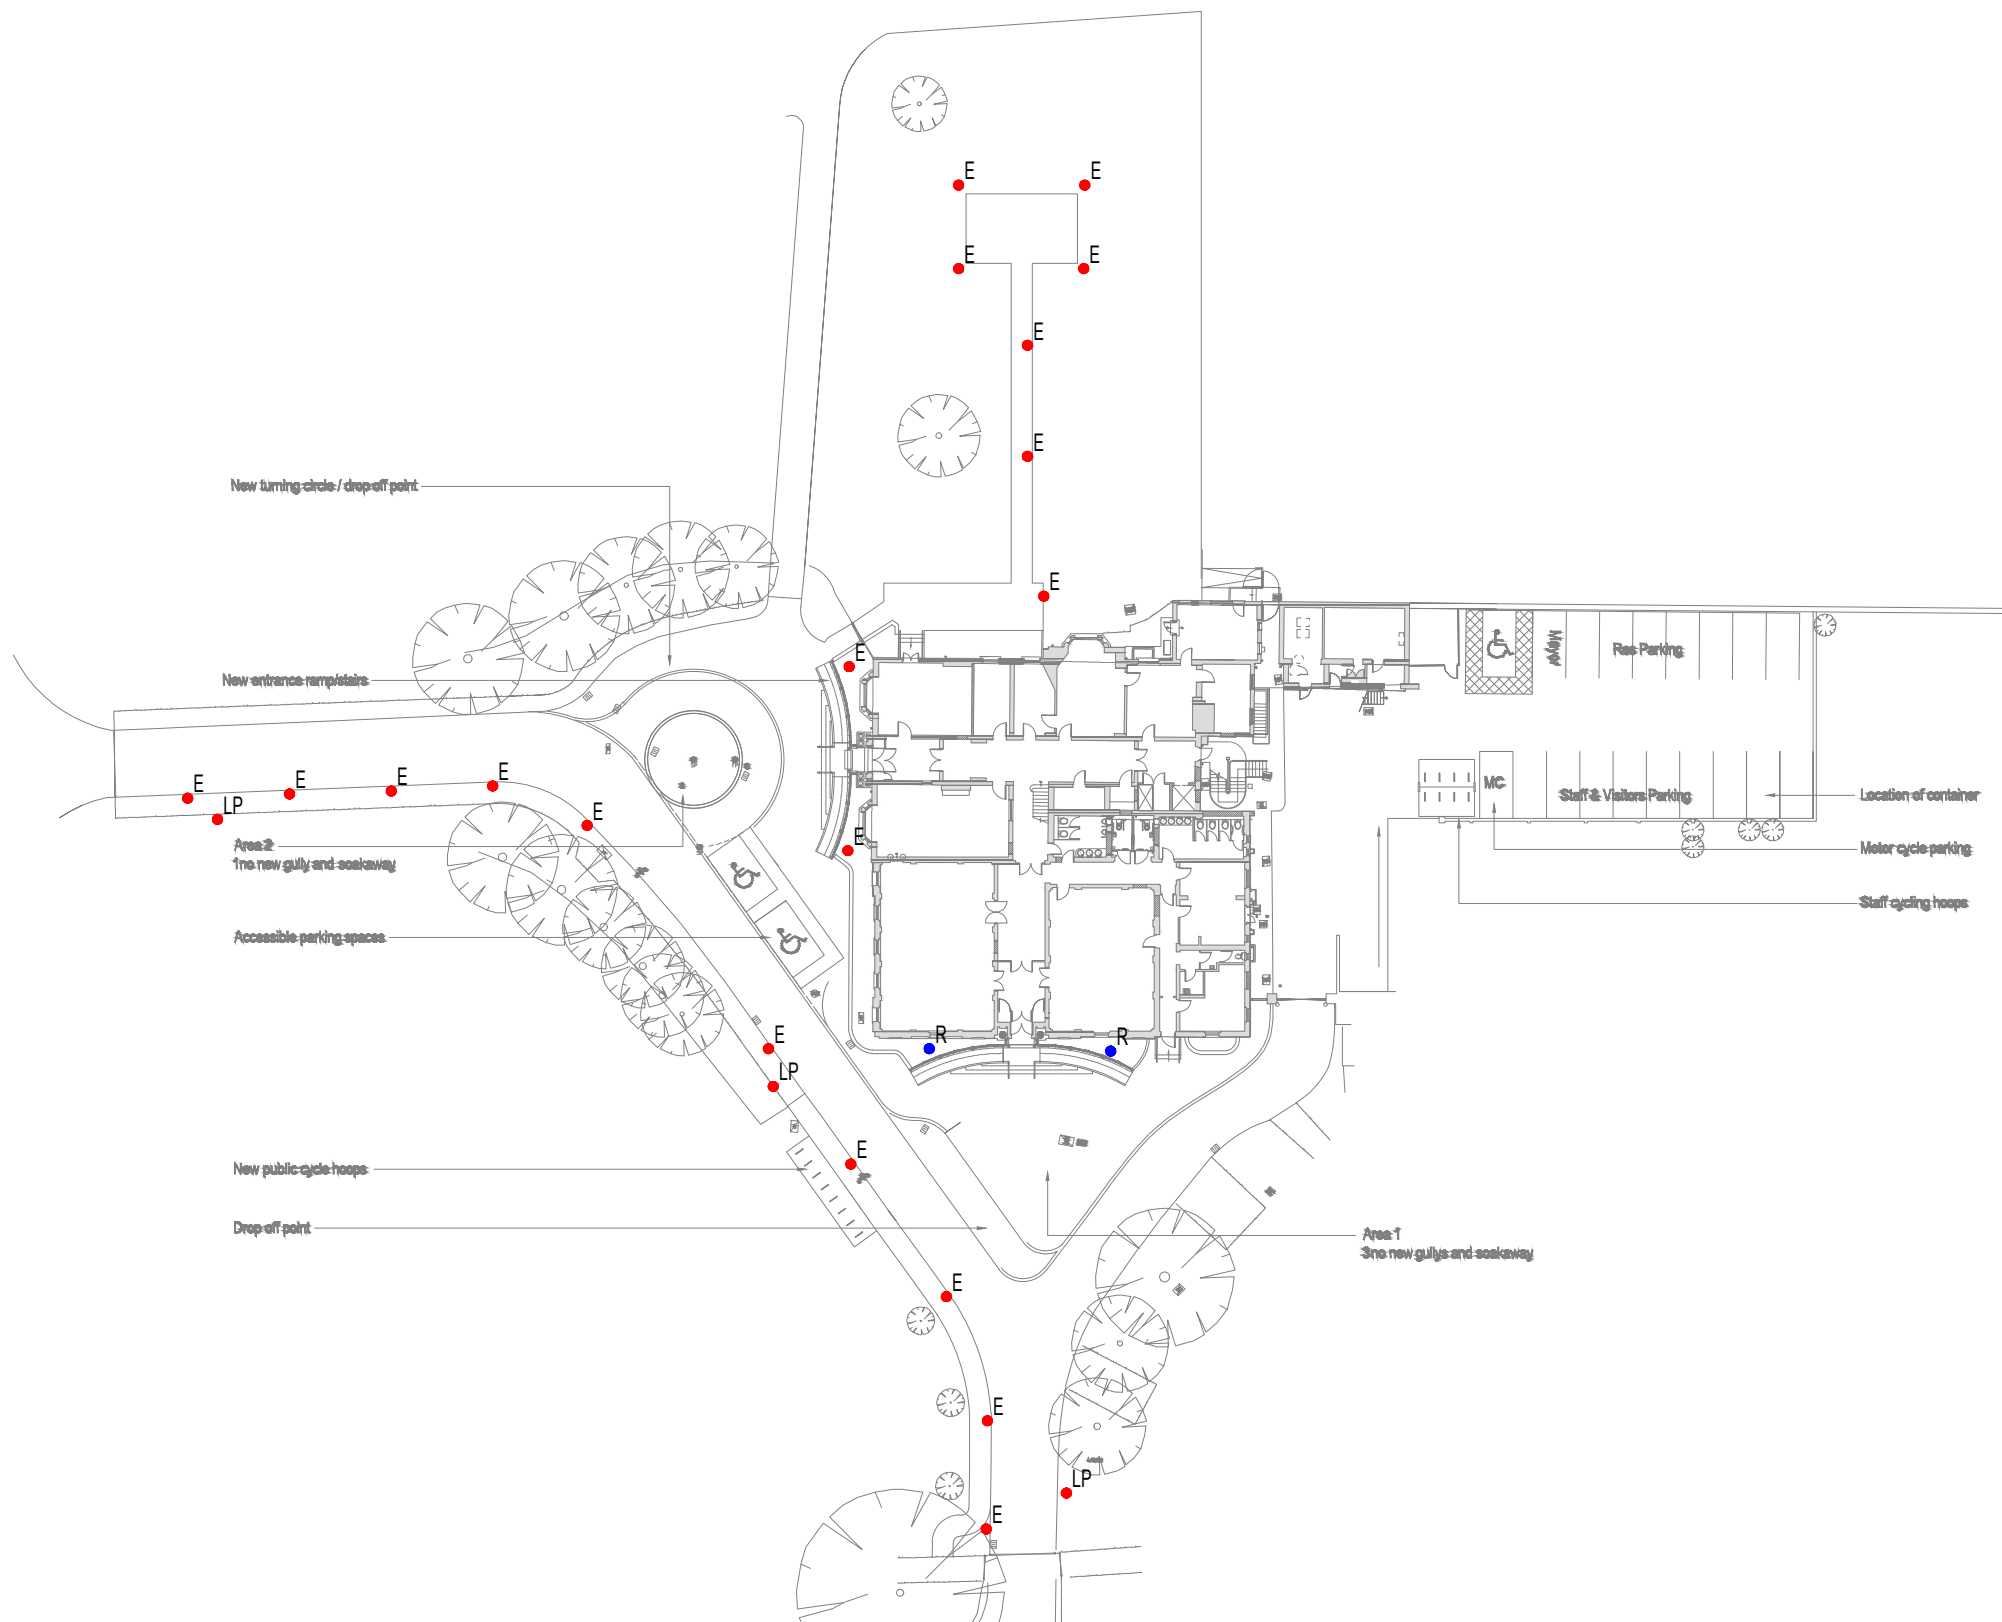

- LEGEND:-
- E EXISTING LIGHTING BOLLARD TO BE STRIPPED OUT
 - LP EXISTING LIGHTING COLUMN TO BE STRIPPED OUT
 - R EXISTING LIGHTING BOLLARD TO BE RETAINED

04.06.2024	TENDER ISSUE	T1	MDB	AM
date	description	rev	by	chkd



SURE CONSULTING
TRIDENT HOUSE
KINGSTON ROAD, LEATHERHEAD
SURREY KT22 7LT
Tel. 01372 365040
e-mail: suregroup@btinternet.com
CONSULTING ENGINEERS

project
George Meehan House

title
External Lighting Layout
Existing

date 31.05.2024
scale 1:500 @ A3

drawing no. 4909-E3

rev T1