


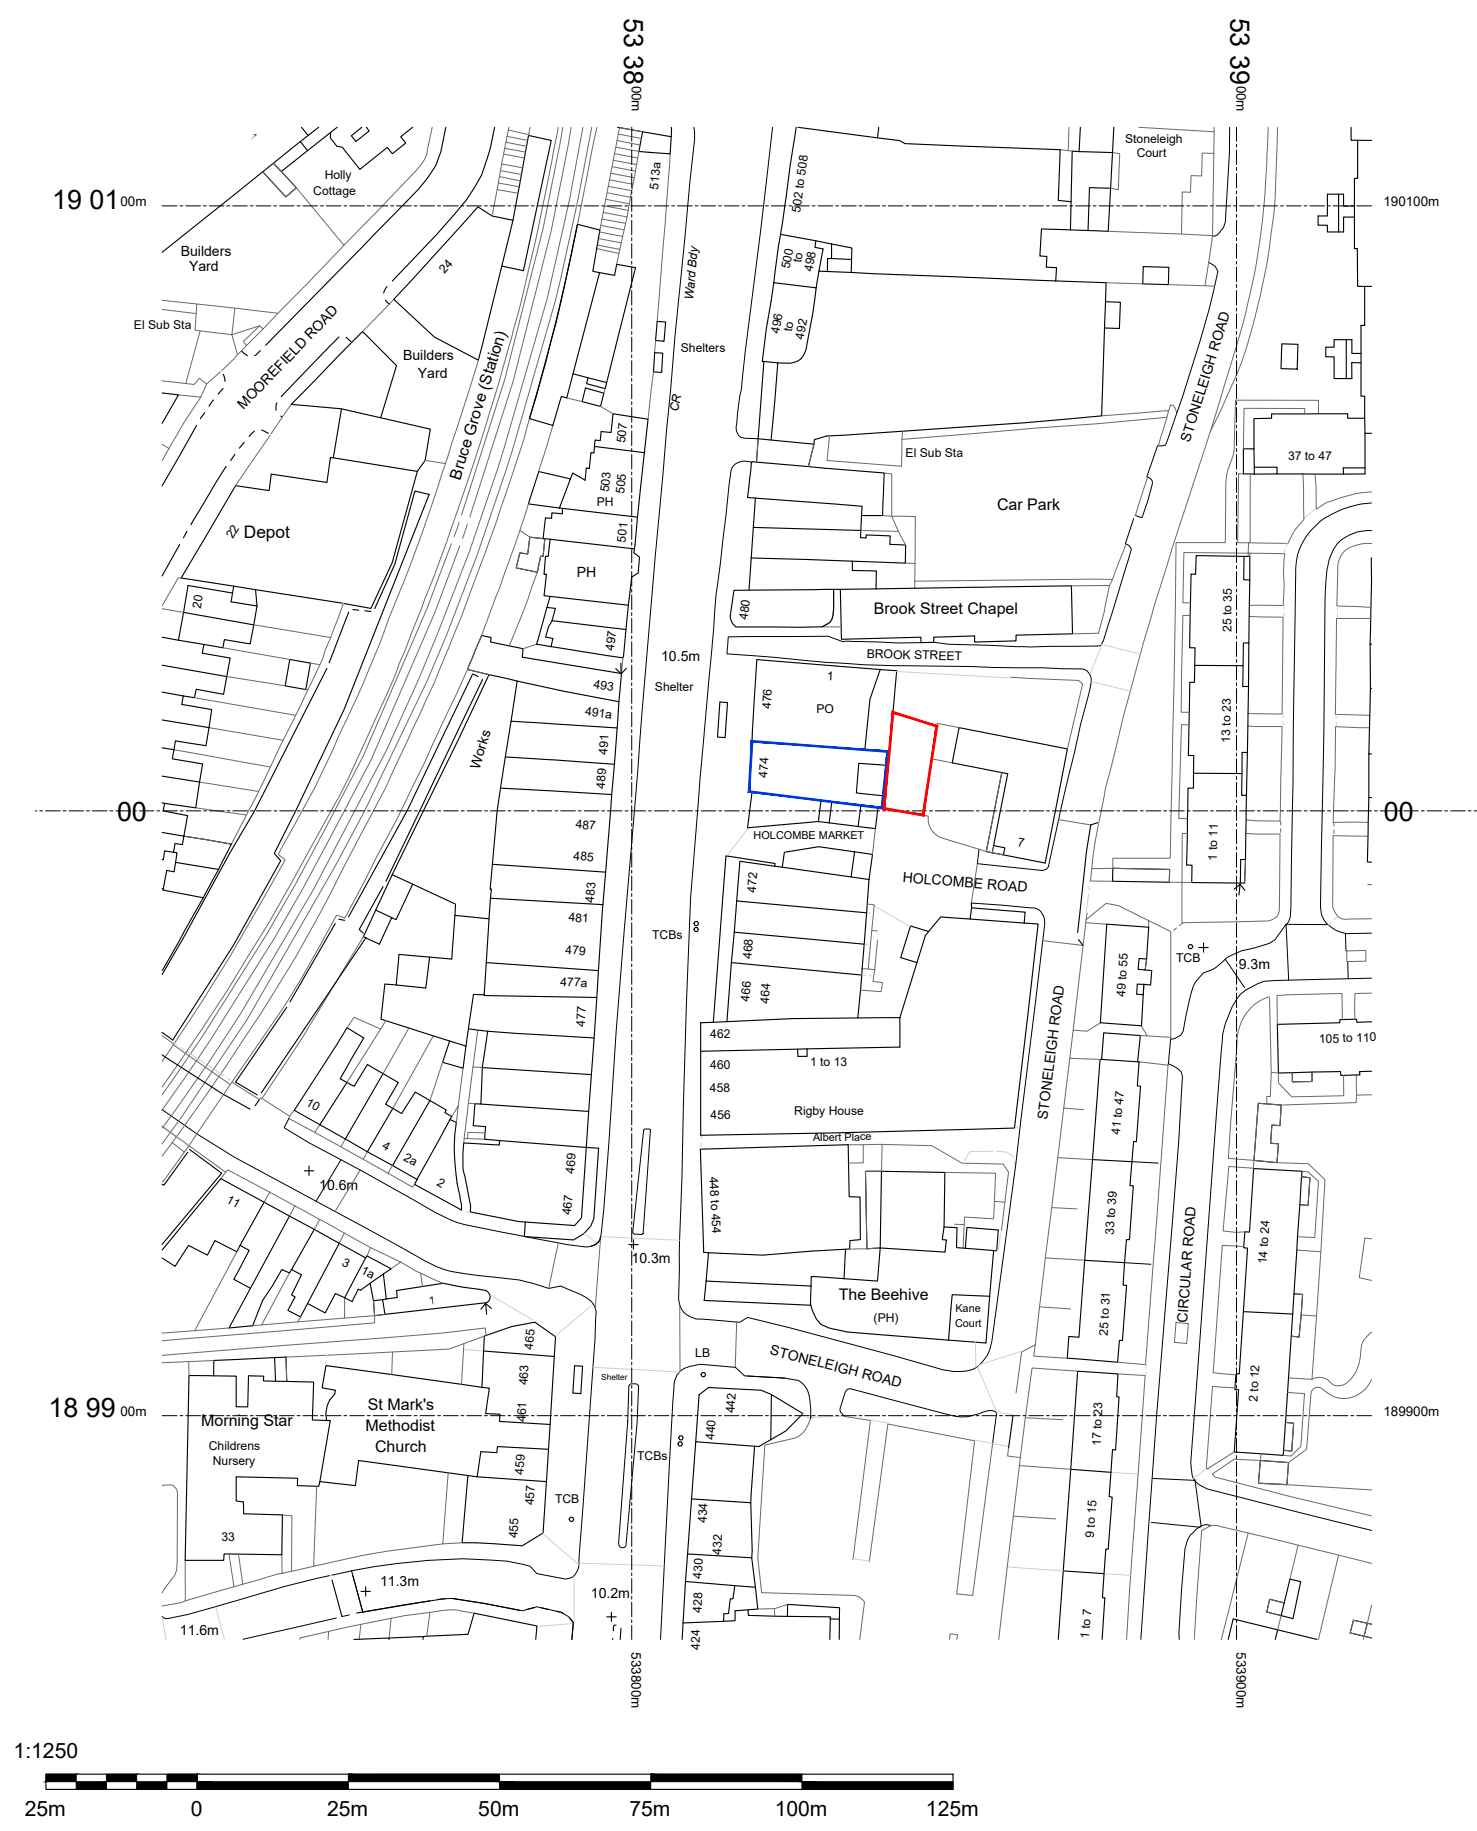


Property:
Private Yard at rear of
474 Tottenham High Road, N17 9JF
Contact:
Mr Asher Solinski
Em: as_659901@talktalk.net mob:


Project: Application for use of back yard at 474 Tottenham High Rd for temporary mobile catering unit with seating
Drawing Title: **Site Location Plan**

Proj. No: RH-07-24A
Scale: 1/1250 @ A3
Dwg No: SP-01
Date: Nov 11 2024
Page: A3

ADM Food Safety & Licensing
Tel: 0208 8861 0400
Mob: 07950 685397
Em: admtraining58@gmail.com

R. Hadidian - Architect, RIBA
44b High Road, Willesden London NW10 2QA
Tel: 07476845478 Em: rhadidian@gmail.com

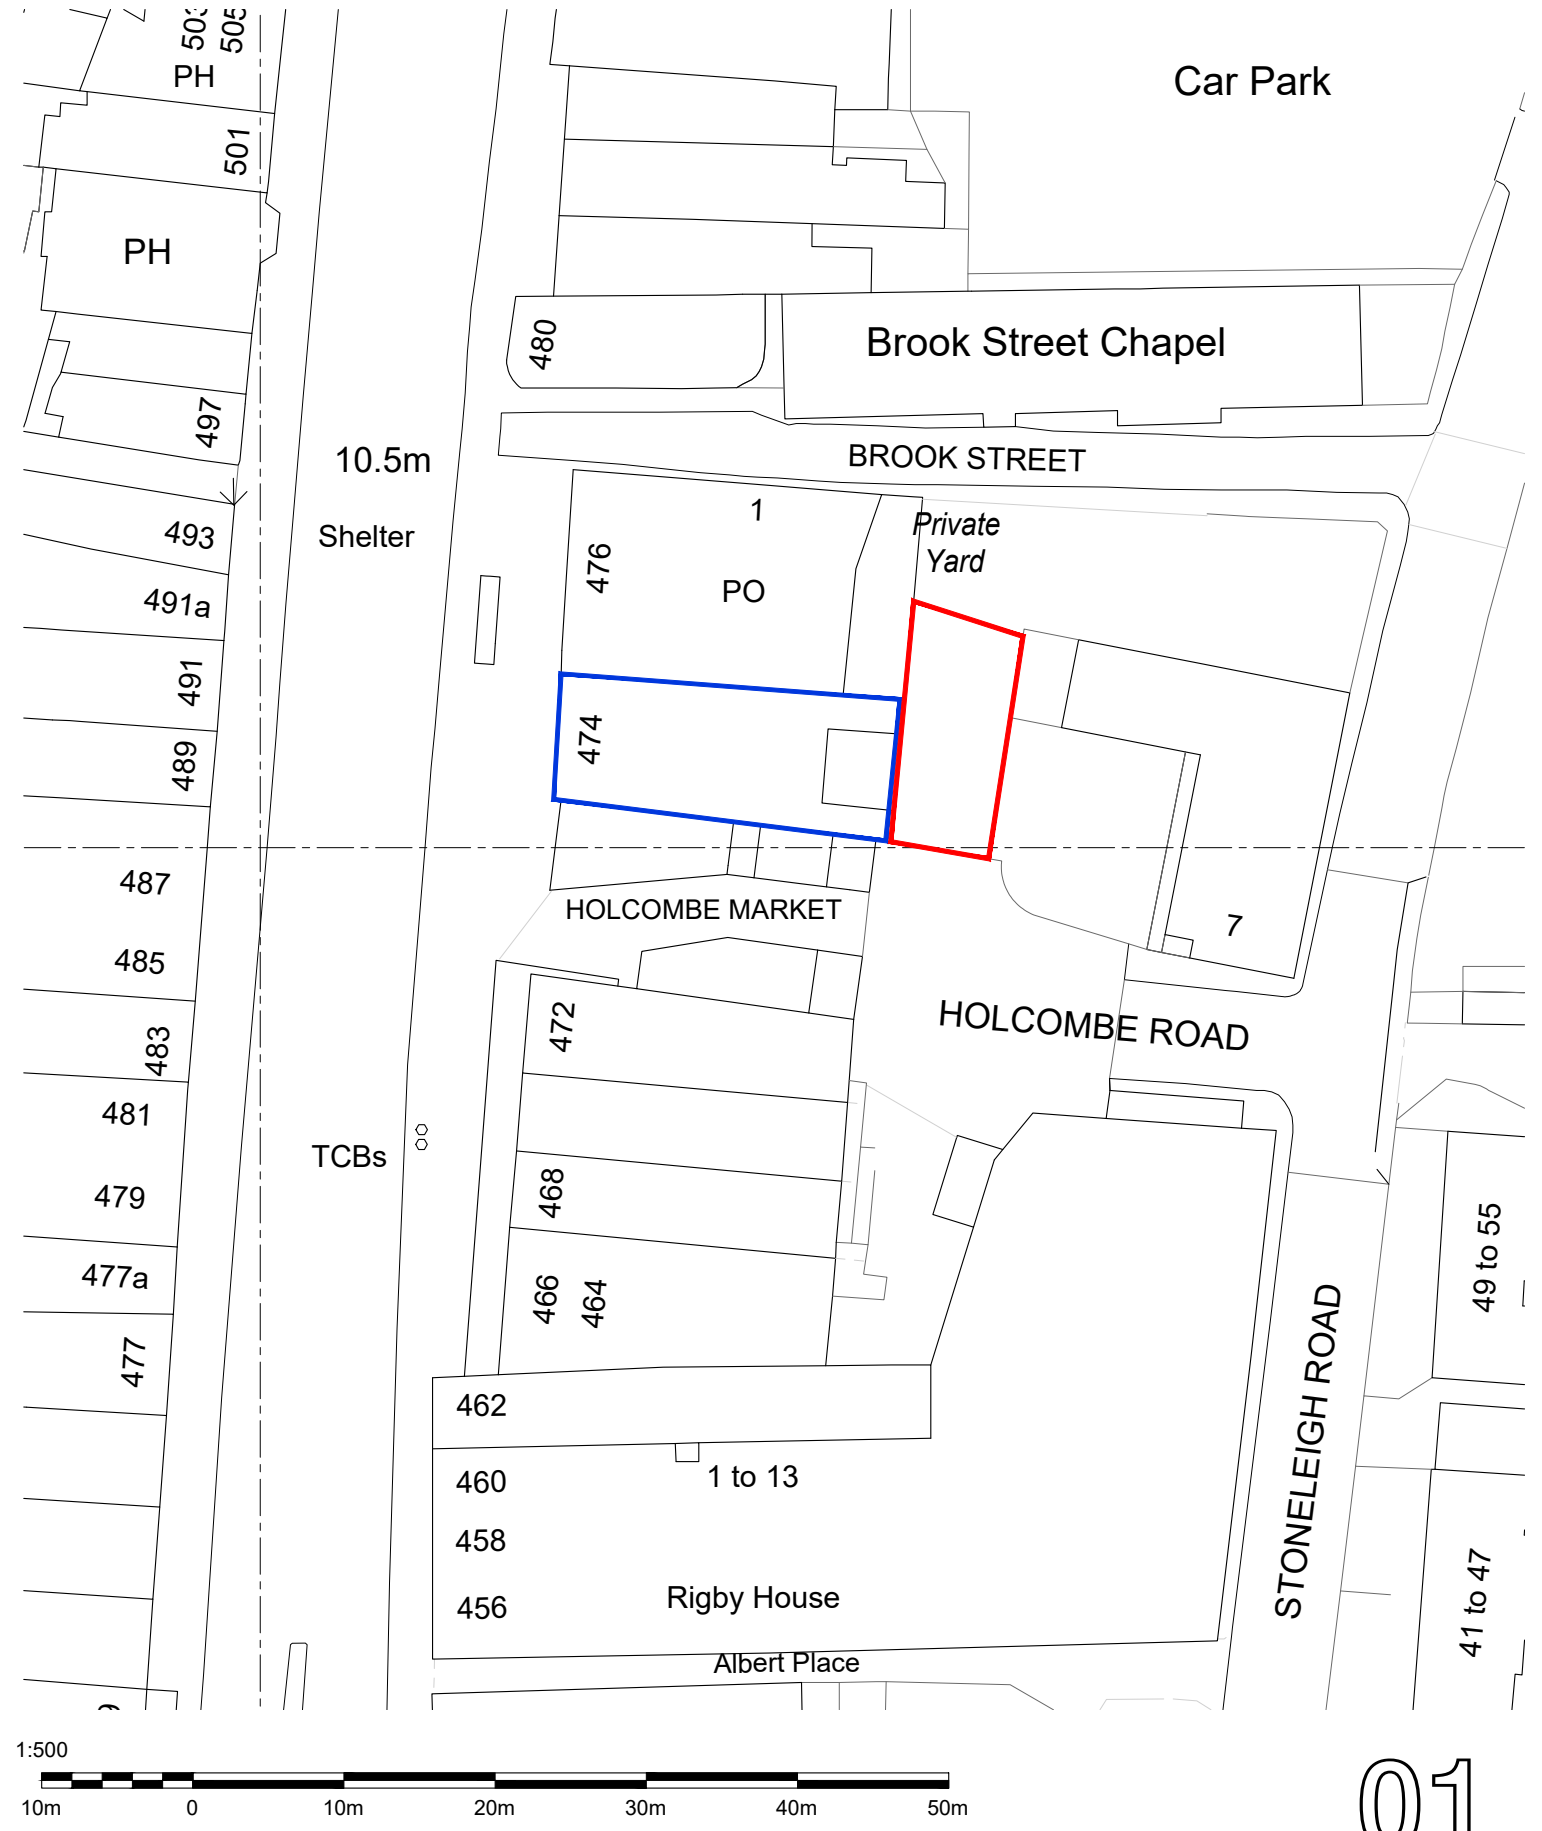

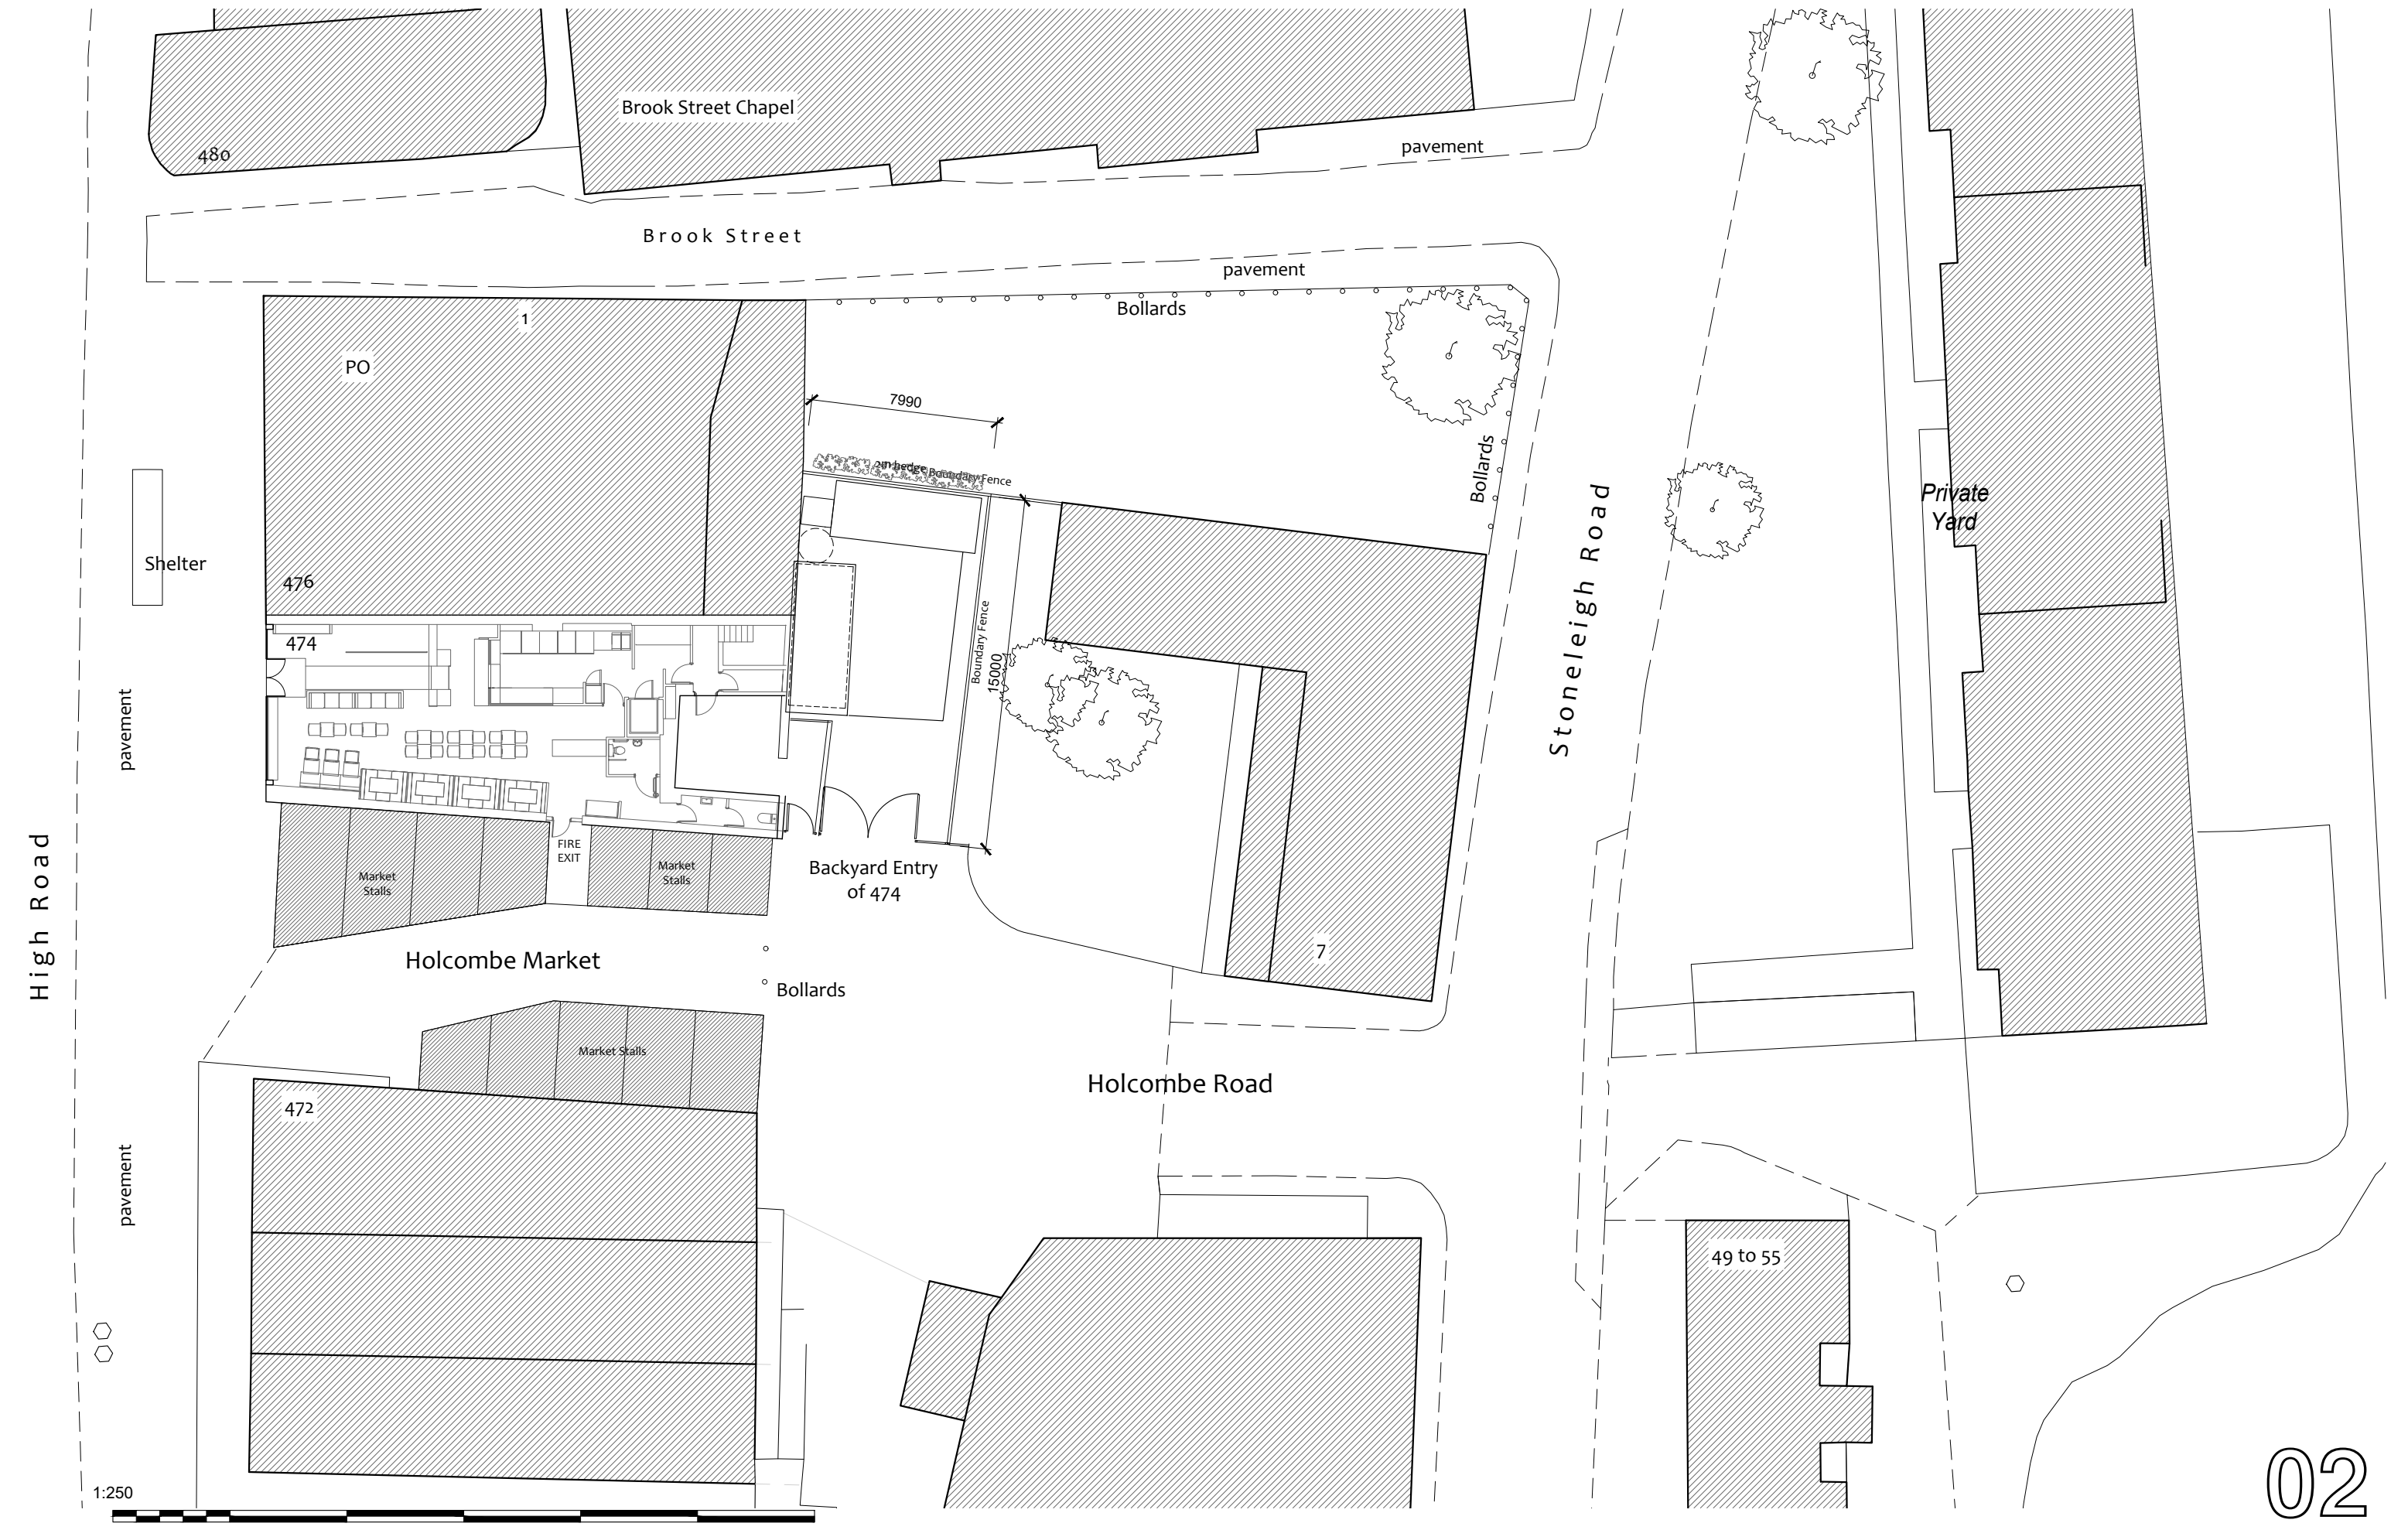

Property:
Private Yard at rear of
474 Tottenham High Road, N17 9JF
Contact:
Mr Asher Solinski
Em: as_659901@talktalk.net mob:

Project:	Application for use of back yard at 474 Tottenham High Rd for temporary mobile catering unit with seating	Proj. No:	RH-07-24A	Date	Nov 11 2024
Drawing Title:	Site Block Plan Proposed	Scale:	1/250 @ A3	Page:	A3
		Dwg No:	SP-02		

ADM Food Safety & Licensing

Tel: 0208 8861 0400

Mob: 07950 685397

Em: admtraining58@gmail.com

R. Hadidian - Architect, RIBA
44b High Road, Willesden London NW10 2QA
Tel:07476845478 Em: rhadidian@gmail.com

High Road

476

474

WC

Mobile
Seating
6.33x2.4m

Backyard
of 474

Mobile
Catering
3.1x2.4m

storage
unit
1.8x1.2m

Boundary Fence

gate

gates

Market Stalls

FIRE EXIT

Market Stalls

Holcombe Market

bollards

Market Stalls



pavement

Property:
**Private Yard at rear of
474 Tottenham High Road, N17 9JF**

Contact:
Mr Asher Solinski
Em: as_659901@talktalk.net mob:

Project: Application for use of back yard at 474 Tottenham High Rd
for temporary mobile catering unit with seating

Drawing Title:
Existing Yard Plan


Proj. No: RH-07-24A
Scale: 1/100 @ A3
Dwg No: GA-01

Date
Nov 11 2024
Page: A3



R. Hadidian - Architect, RIBA
44b High Road, Willesden London NW10 2QA
Tel: 07476845478 Em: rhadidian@gmail.com

03

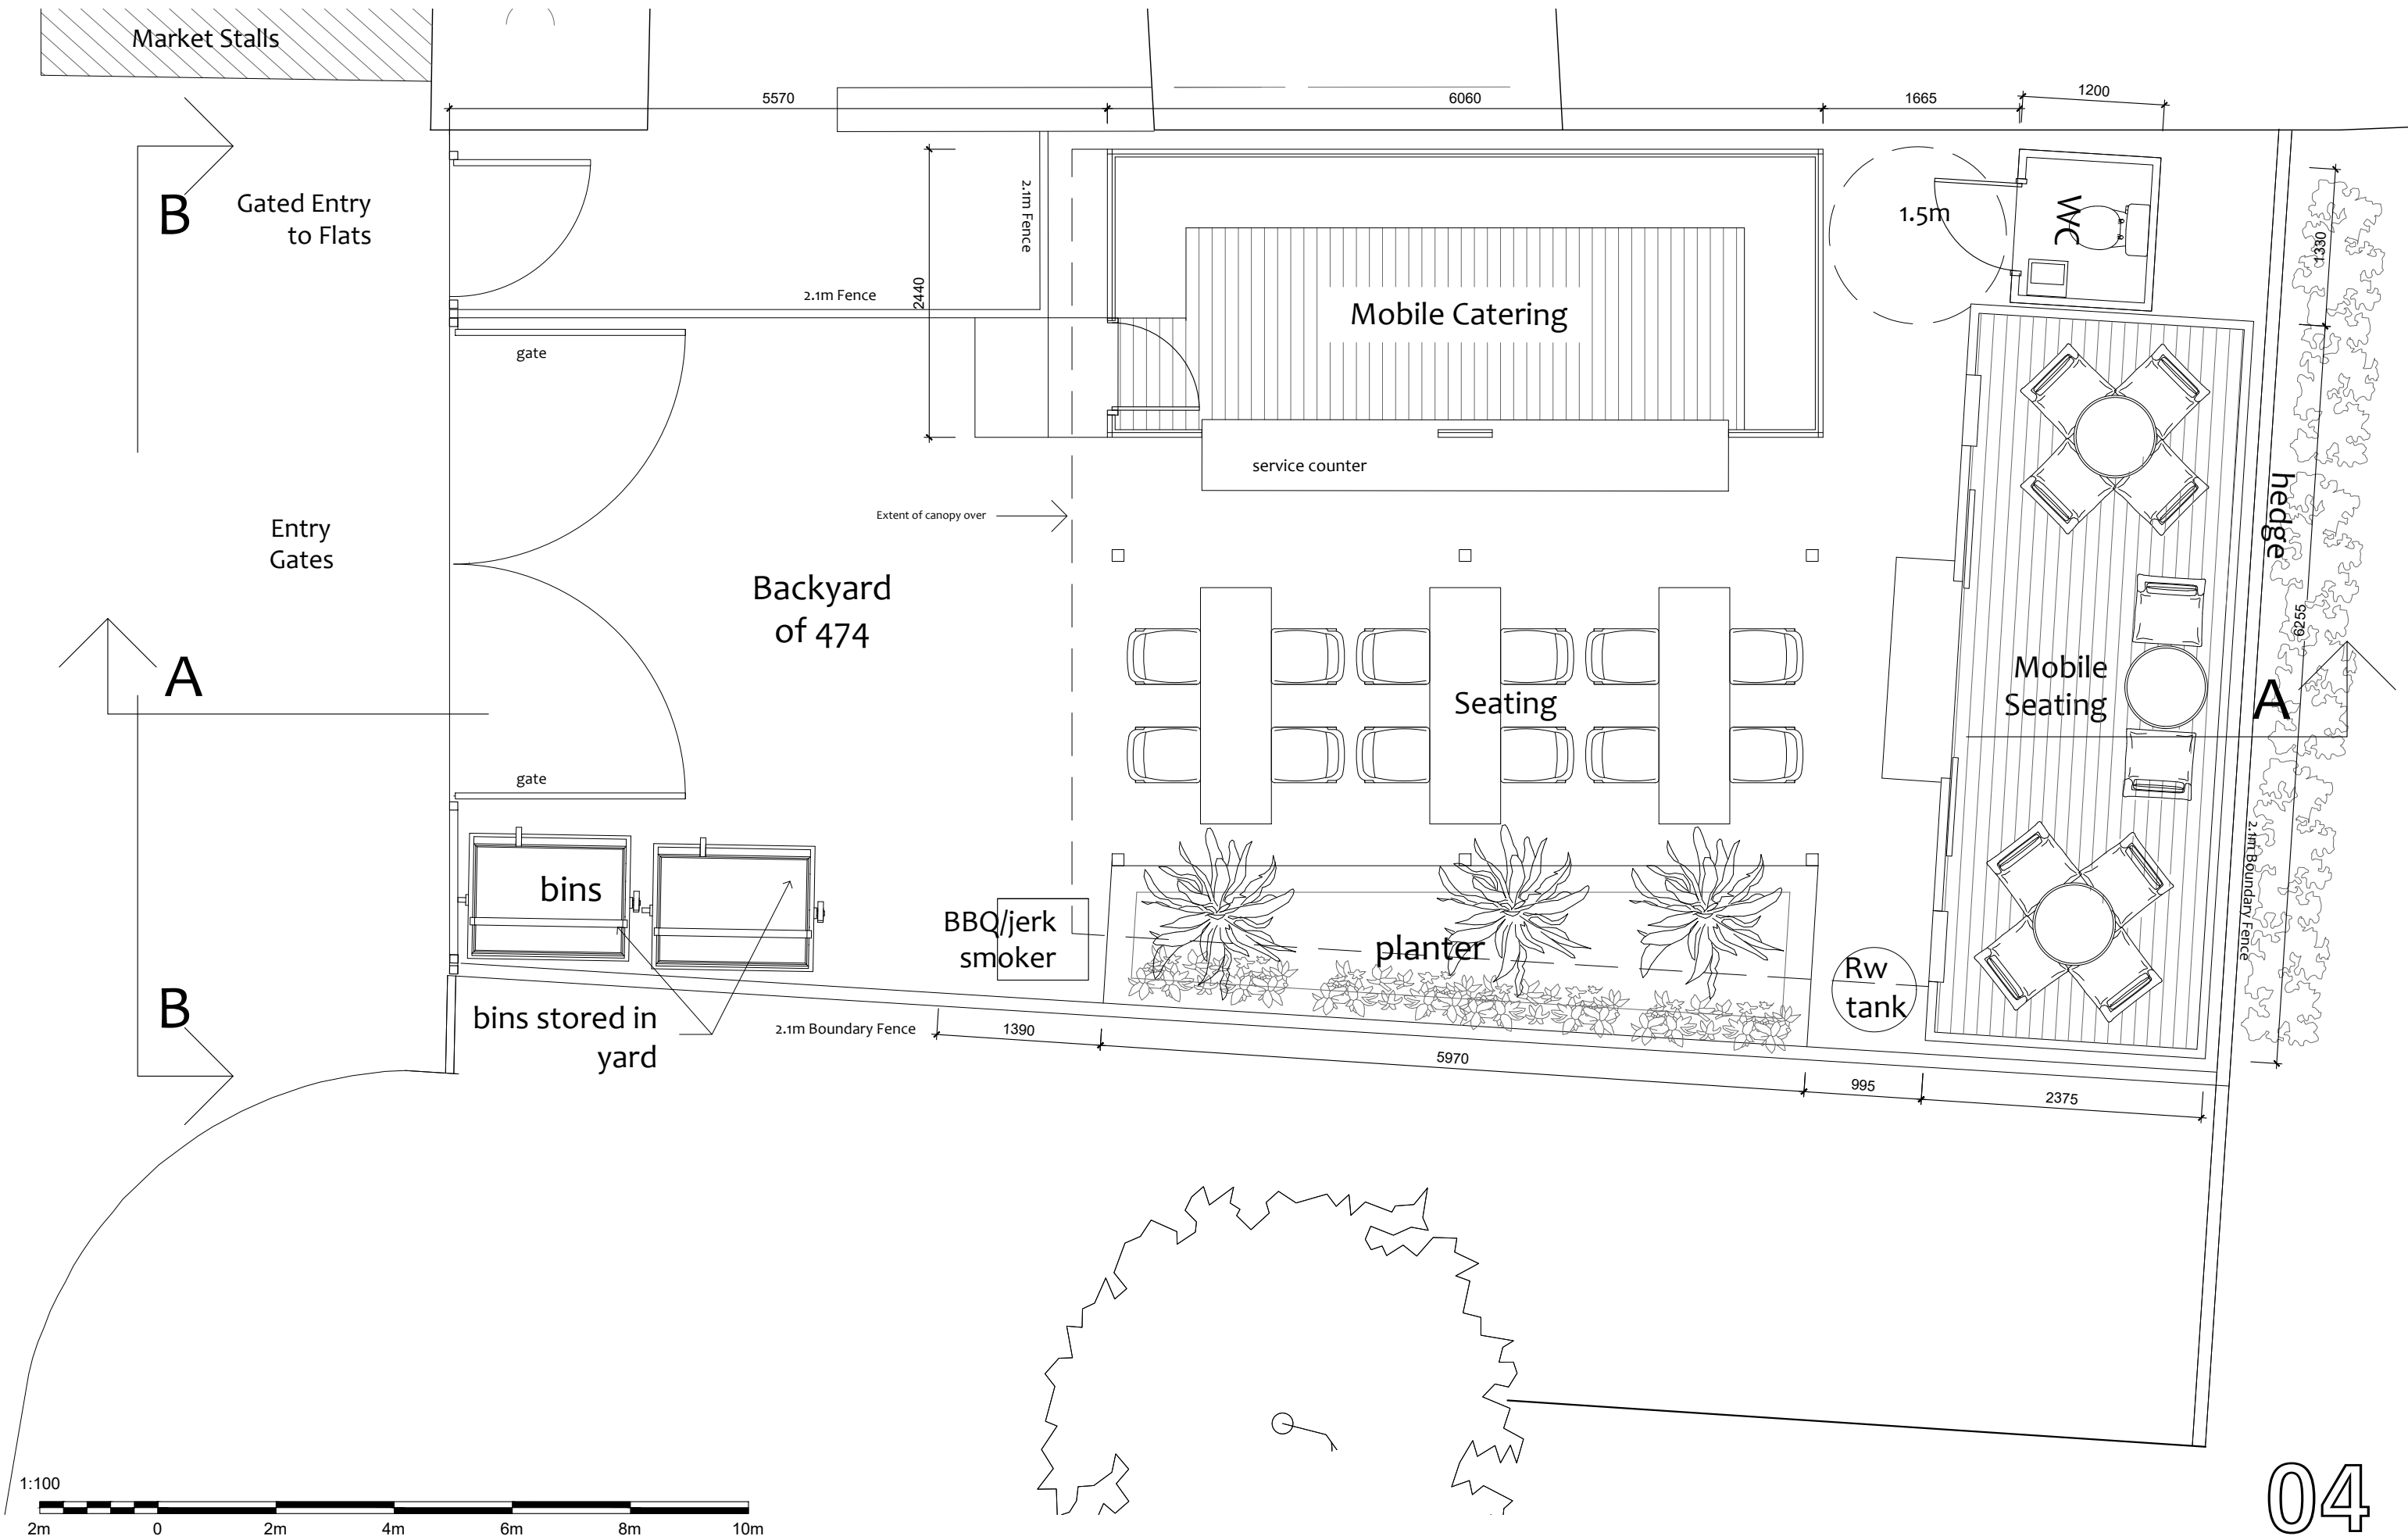


Property:
Private Yard at rear of
474 Tottenham High Road, N17 9JF
Contact:
Mr Asher Solinski
Em: as_659901@talktalk.net mob:

Project: Application for use of back yard at 474 Tottenham High Rd
for temporary mobile catering unit with seating
Drawing Title: **Proposed Yard Plan**

Proj. No: RH-07-24A
Scale: **1/100 @ A3**
Dwg No: **GA-02**
Date: Nov 11 2024
Page: **A3**

ADM Food Safety & Licensing
Tel: 0208 8861 0400
Mob: 07950 685397
Em: admtraining58@gmail.com

R. Hadidian - Architect, RIBA
44b High Road, Willesden London NW10 2QA
Tel: 07476845478 Em: rhadidian@gmail.com

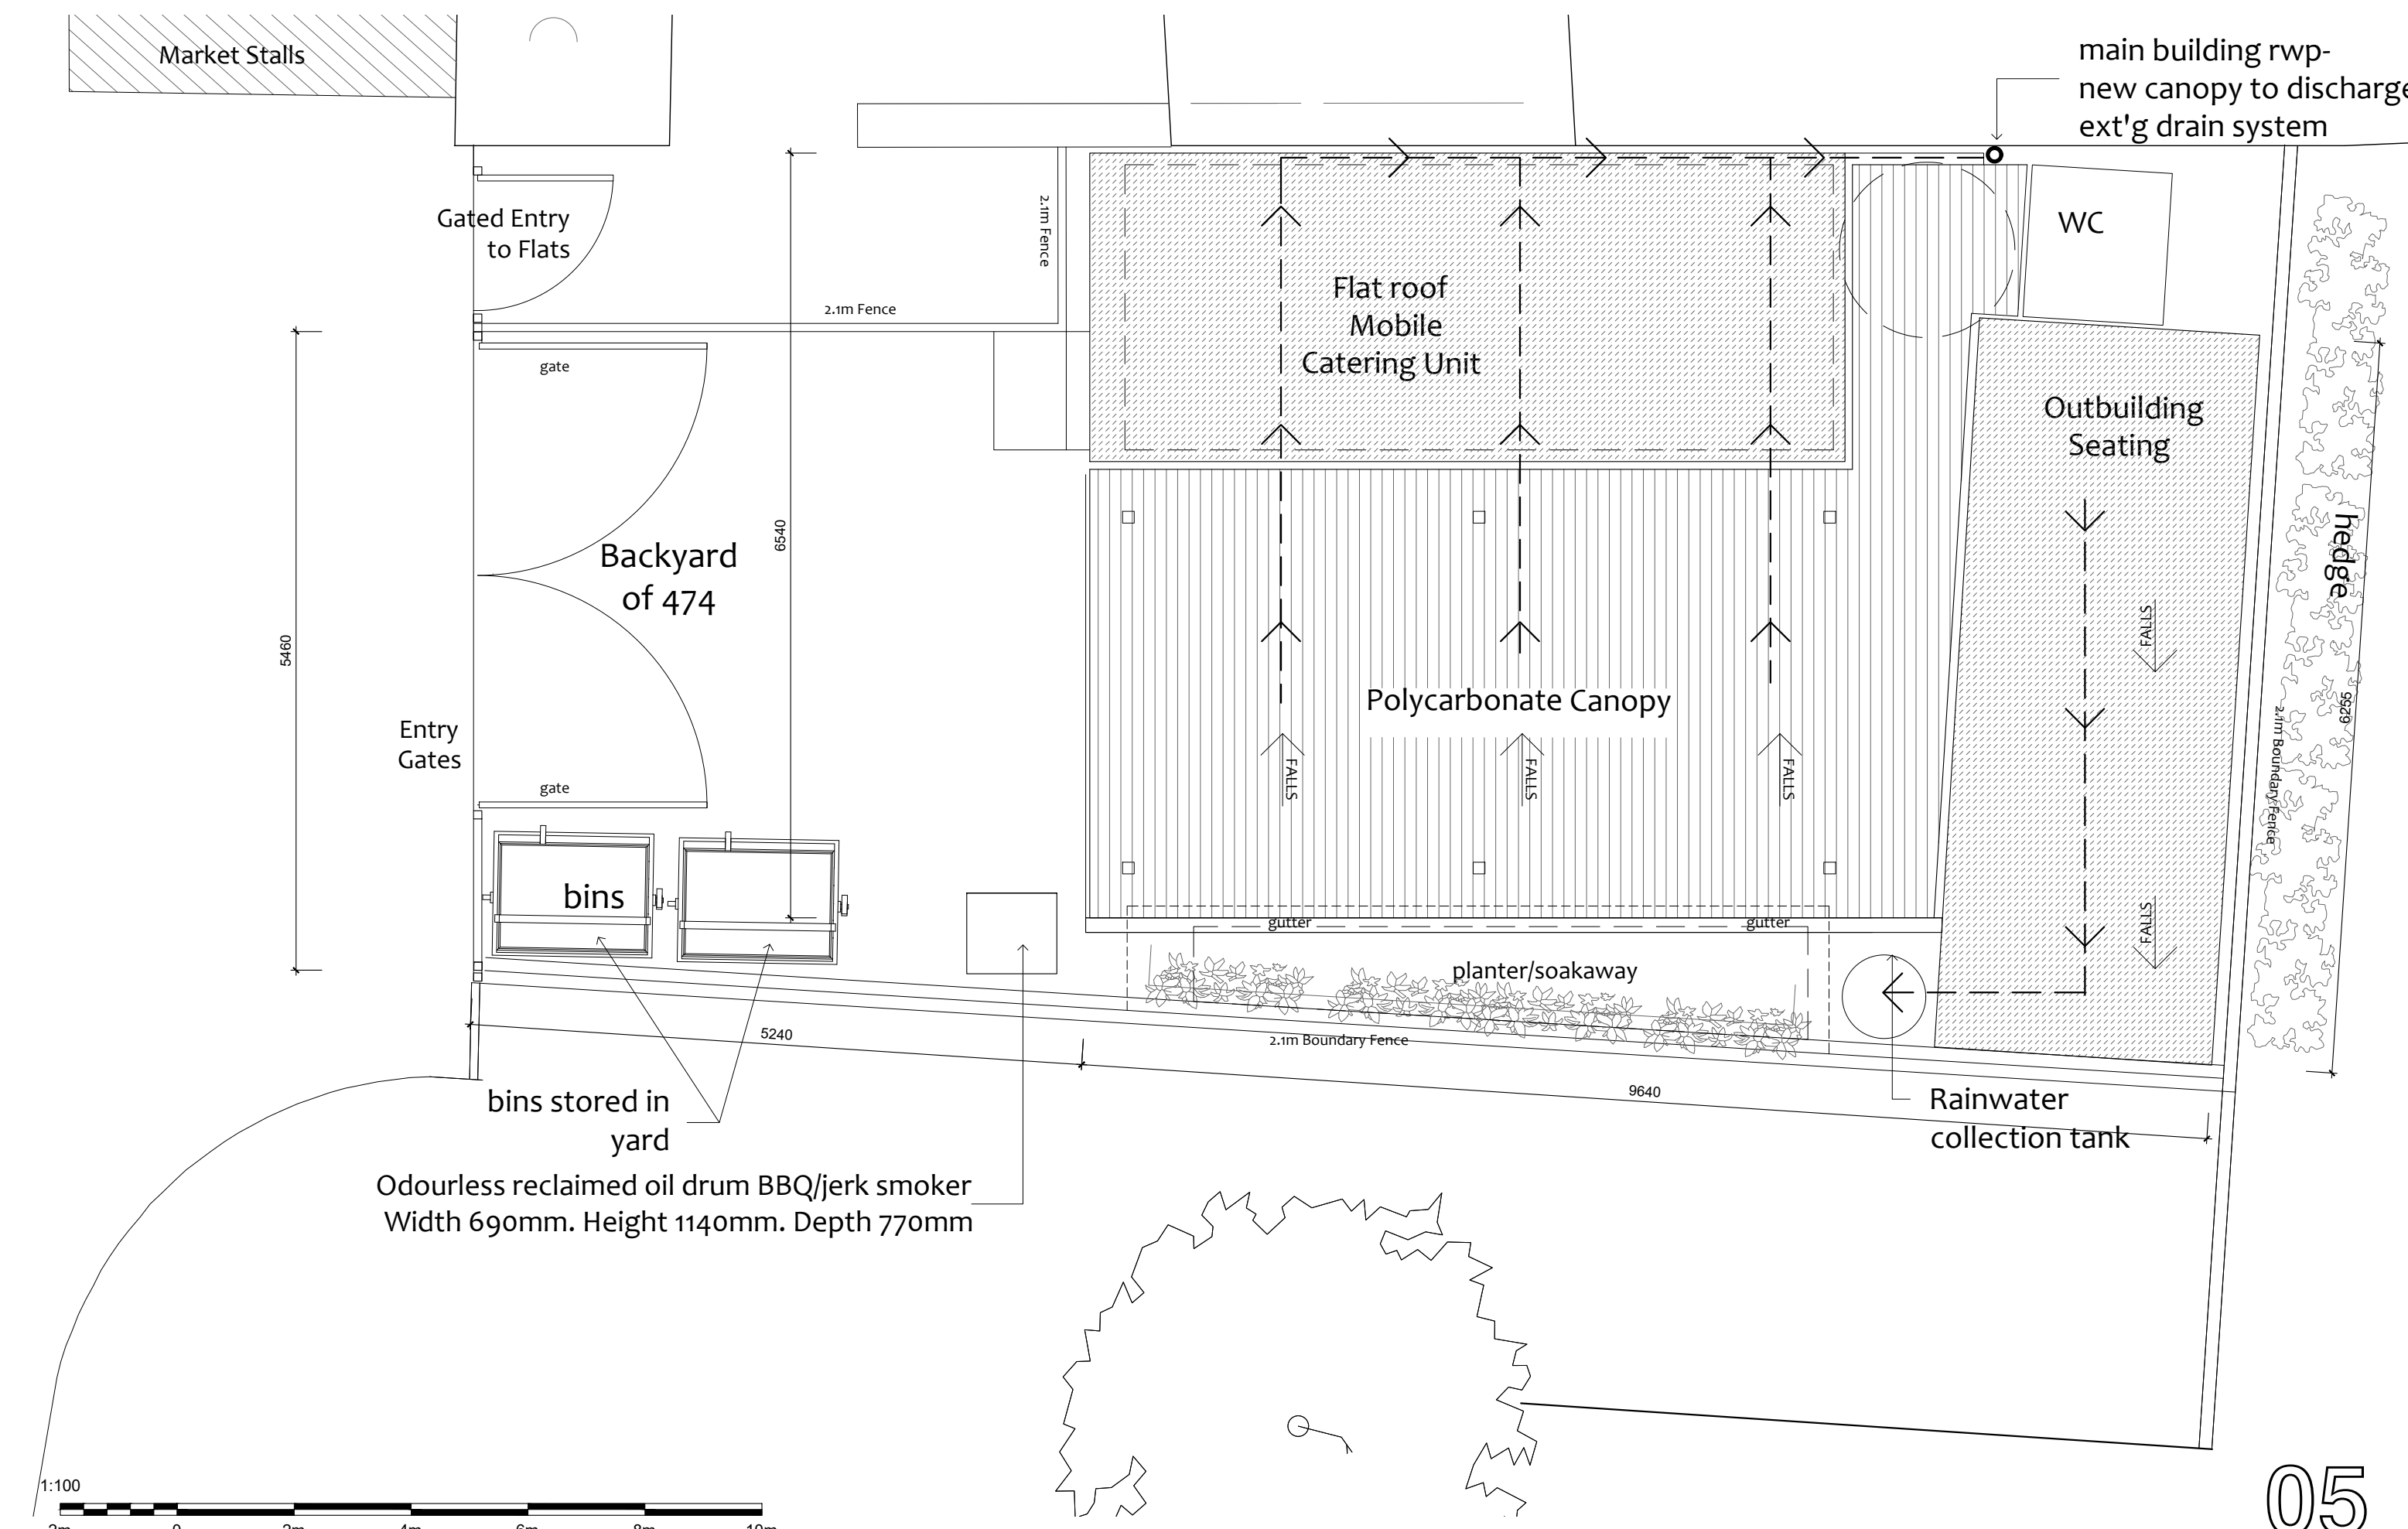

Property:
Private Yard at rear of
474 Tottenham High Road, N17 9JF
Contact:
Mr Asher Solinski
Em: as_659901@talktalk.net mob:

Project:	Application for use of back yard at 474 Tottenham High Rd for temporary mobile catering unit with seating		
Drawing Title:	Proposed Yard Roof Plan		
Proj. No:	RH-07-24A	Date	Nov 11 2024
Scale:	1/100 @ A3	Page:	A3
Dwg No:	GA-03		


ADM Food Safety & Licensing

Tel: 0208 8861 0400

Mob: 07950 685397

Em: admtraining58@gmail.com

R. Hadidian - Architect, RIBA
44b High Road, Willesden London NW10 2QA
Tel:07476845478 Em: rhadidian@gmail.com

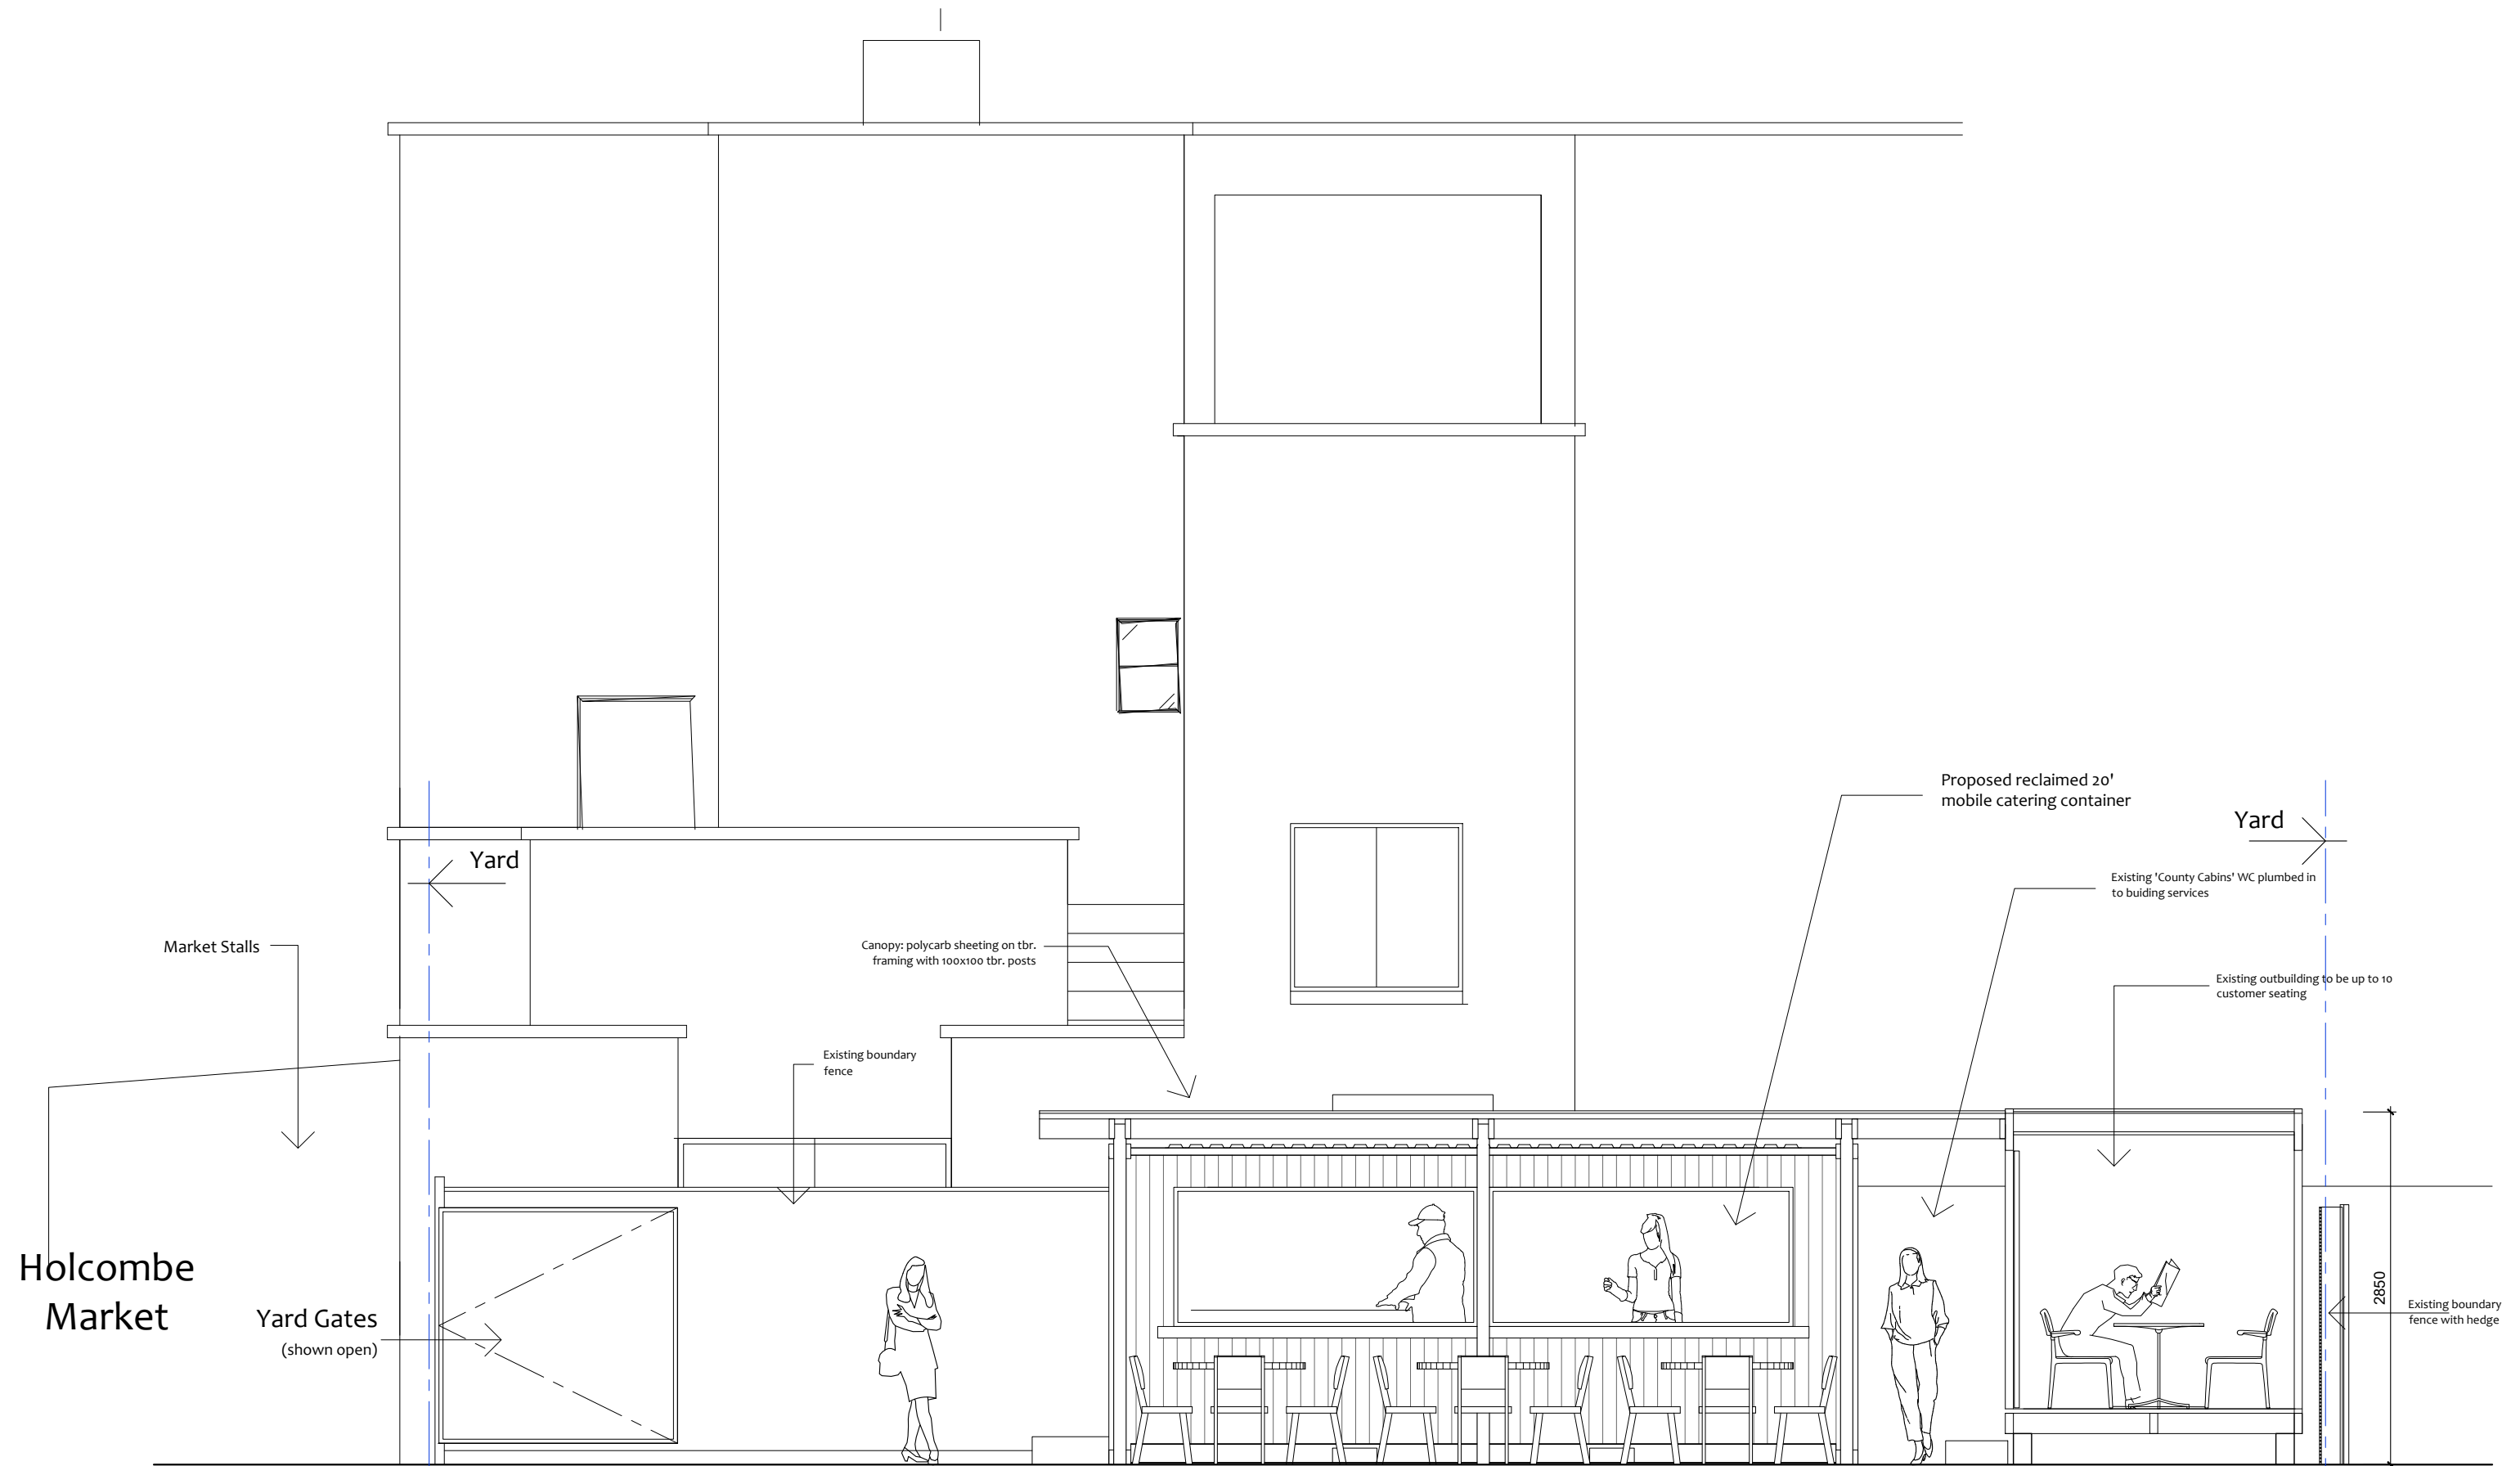

1:50
1m 0 1m 2m 3m 4m 5m

Proposed Yard Sectional Elevation A-A

06

Property:
Private Yard at rear of
474 Tottenham High Road, N17 9JF
Contact:
Mr Asher Solinski
Em: as_659901@talktalk.net mob:


Project: Application for use of back yard at 474 Tottenham High Rd
for temporary mobile catering unit with seating
Drawing Title: **Proposed Yard Elevation A-A**

Proj. No: RH-07-24A
Scale: **1/50 @ A3**
Dwg No: **EL-01**

Date
Nov 11 2024
Page: **A3**

ADM Food Safety
& Licensing
Tel: **0208 8861 0400**
Mob: **07950 685397**
Em: admtraining58@gmail.com

R. Hadidian - Architect, RIBA
44b High Road, Willesden London NW10 2QA
Tel: 07476845478 Em: rhadidian@gmail.com

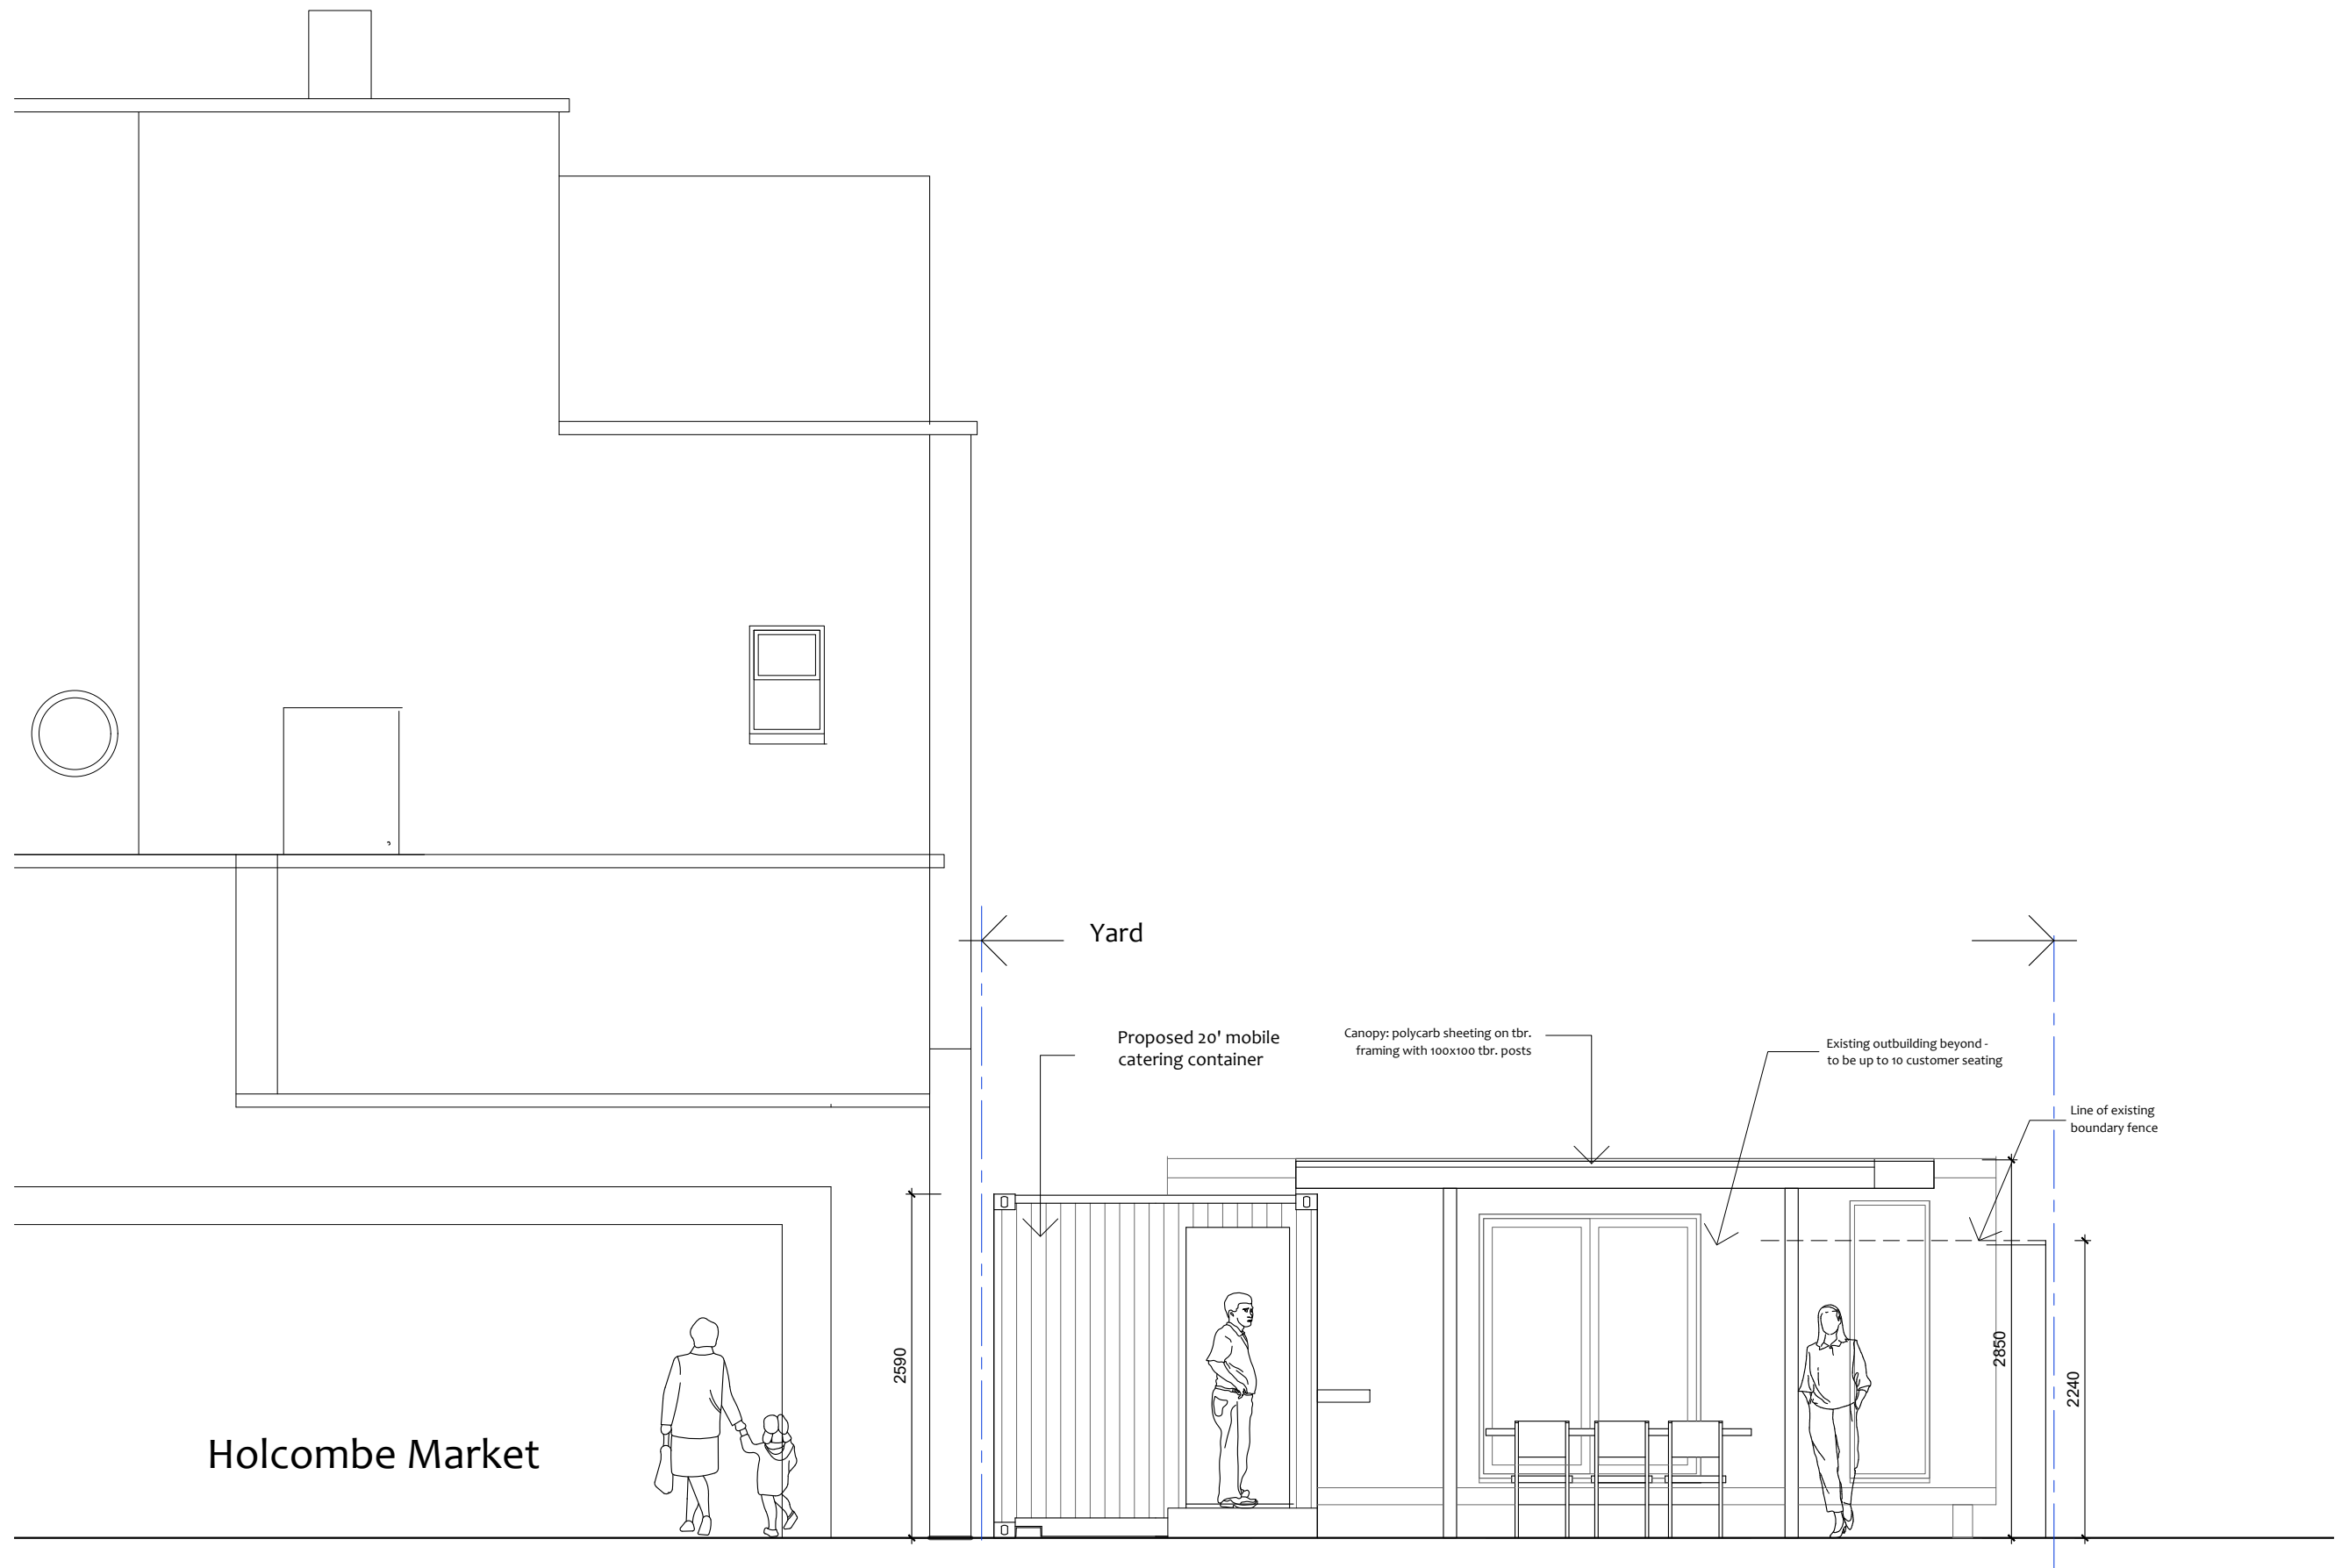

Proposed Holcombe Road Elevation B-B
(gates omitted for clarity)

07



Property:
Private Yard at rear of
474 Tottenham High Road, N17 9JF
Contact:
Mr Asher Solinski
Em: as_659901@talktalk.net mob:


Project: Application for use of back yard at 474 Tottenham High Rd
for temporary mobile catering unit with seating
Drawing Title: **Proposed Yard Elevation B-B**

Proj. No: RH-07-24A
Scale: **1/50 @ A3**
Dwg No: **EL-02**

Date
Nov 11 2024
Page: **A3**



R. Hadidian - Architect, RIBA
44b High Road, Willesden London NW10 2QA
Tel: 07476845478 Em: rhadidian@gmail.com

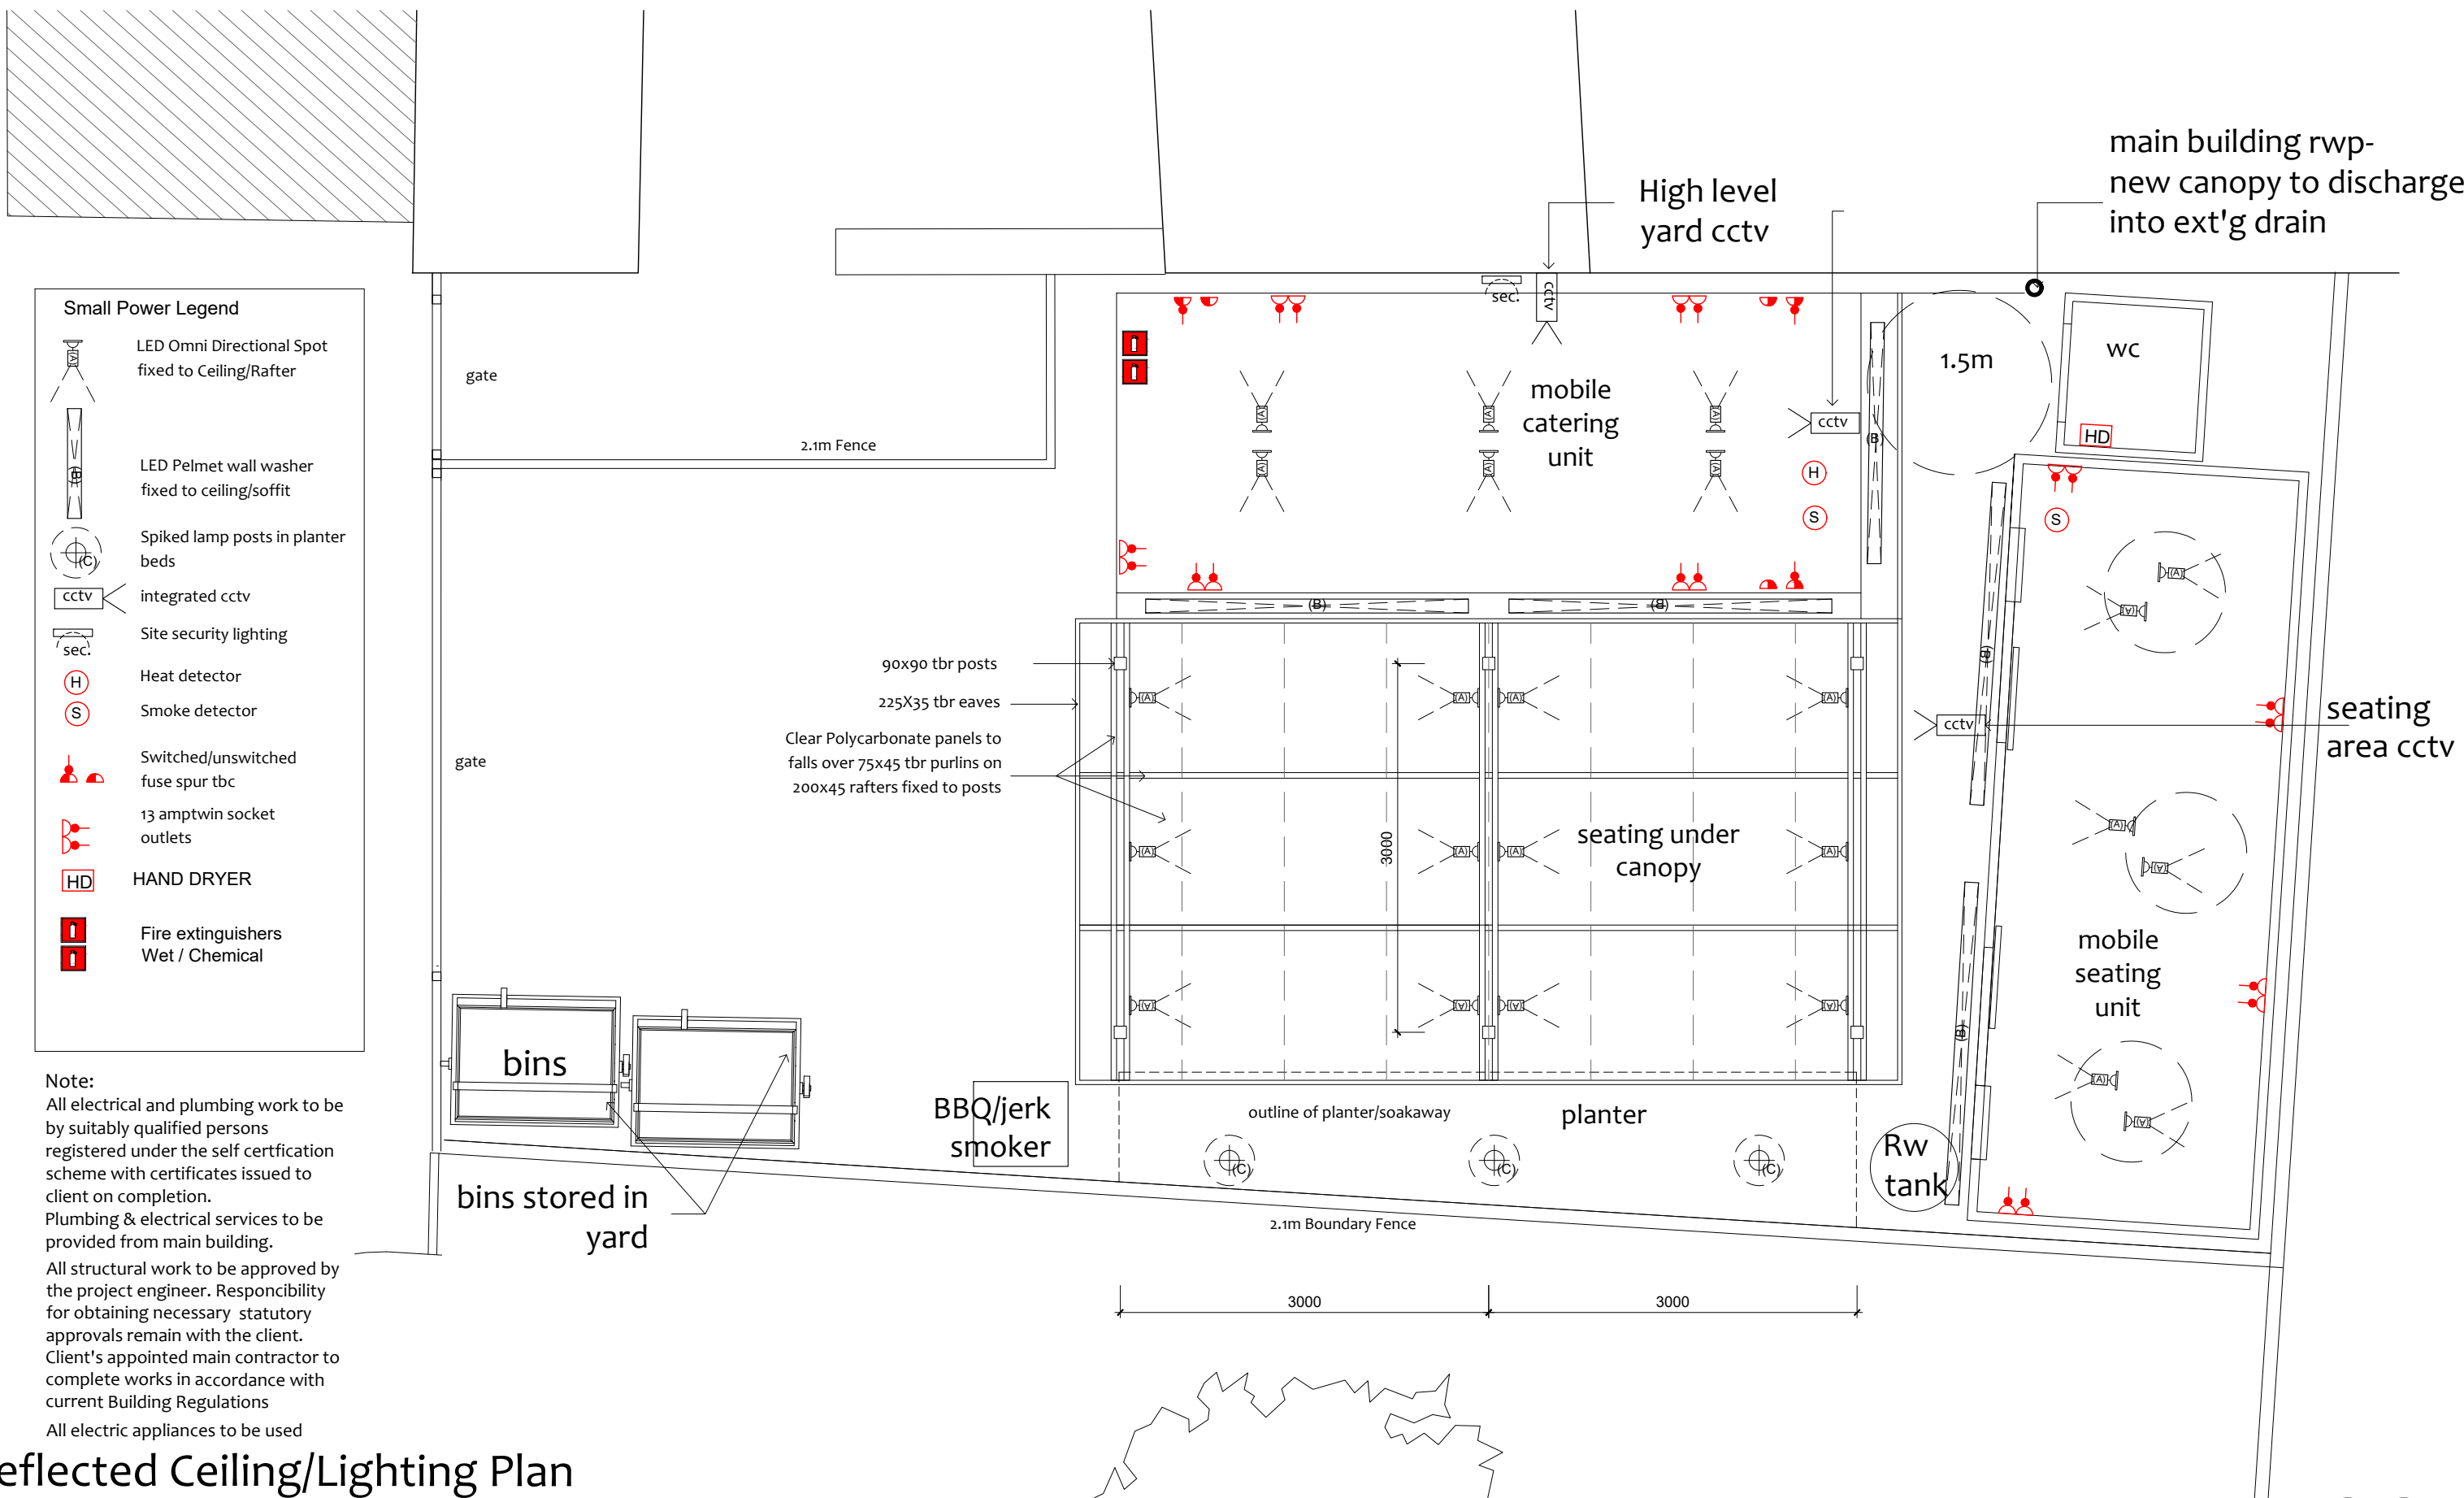


Small Power Legend

- LED Omni Directional Spot fixed to Ceiling/Rafter
- LED Pelmet wall washer fixed to ceiling/soffit
- Spiked lamp posts in planter beds
- integrated CCTV
- Site security lighting
- Heat detector
- Smoke detector
- Switched/unswitched fuse spur tbc
- 13 amptwin socket outlets
- HAND DRYER
- Fire extinguishers Wet / Chemical

Note:
All electrical and plumbing work to be by suitably qualified persons registered under the self certification scheme with certificates issued to client on completion.
Plumbing & electrical services to be provided from main building.
All structural work to be approved by the project engineer. Responsibility for obtaining necessary statutory approvals remain with the client.
Client's appointed main contractor to complete works in accordance with current Building Regulations
All electric appliances to be used

 Reflected Ceiling/Lighting Plan



Property:
Private Yard at rear of
474 Tottenham High Road, N17 9JF
Contact:
Mr Asher Solinski
Em: as_659901@talktalk.net mob:

Project: Application for use of back yard at 474 Tottenham High Rd for temporary mobile catering unit with seating
Drawing Title: **Reflected Ceiling/ Lighting Plan**

Proj. No: RH-07-24A
Scale: **1/50 @ A3**
Dwg No: **LGH-01**

Date
Nov 11 2024
Page:
A3

ADM Food Safety & Licensing
Tel: 0208 8861 0400
Mob: 07950 685397
Em: admtraining58@gmail.com

R. Hadidian - Architect, RIBA
44b High Road, Willesden London NW10 2QA
Tel: 07476845478 Em: rhadidian@gmail.com

08